


THE HILLSIDE 7200

DRAWING TITLE			SCALE	SHEET	
TINY HOME VIEWS				A1	
DRAWN BY	CHECKED BY	PROJECT N°	DATE		
FDLS		TheHillside7200_10-09-2020	10-09-2020		



THE HILLSIDE 7200

DRAWING TITLE			SCALE	SHEET
TH INTERIOR VIEWS				A2
DRAWN BY	CHECKED BY	PROJECT N°	DATE	
FDLS		TheHillside7200_10-09-2020	10-09-2020	



1 ROOF
1 : 25




THE HILLSIDE 7200

DRAWING TITLE			SCALE	SHEET
TOP OF TINY HOME			1 : 25	A3
DRAWN BY	CHECKED BY	PROJECT N°	DATE	
FDLS		TheHillside7200_10-09-2020	10-09-2020	



1 FIRST LEVEL
1 : 25

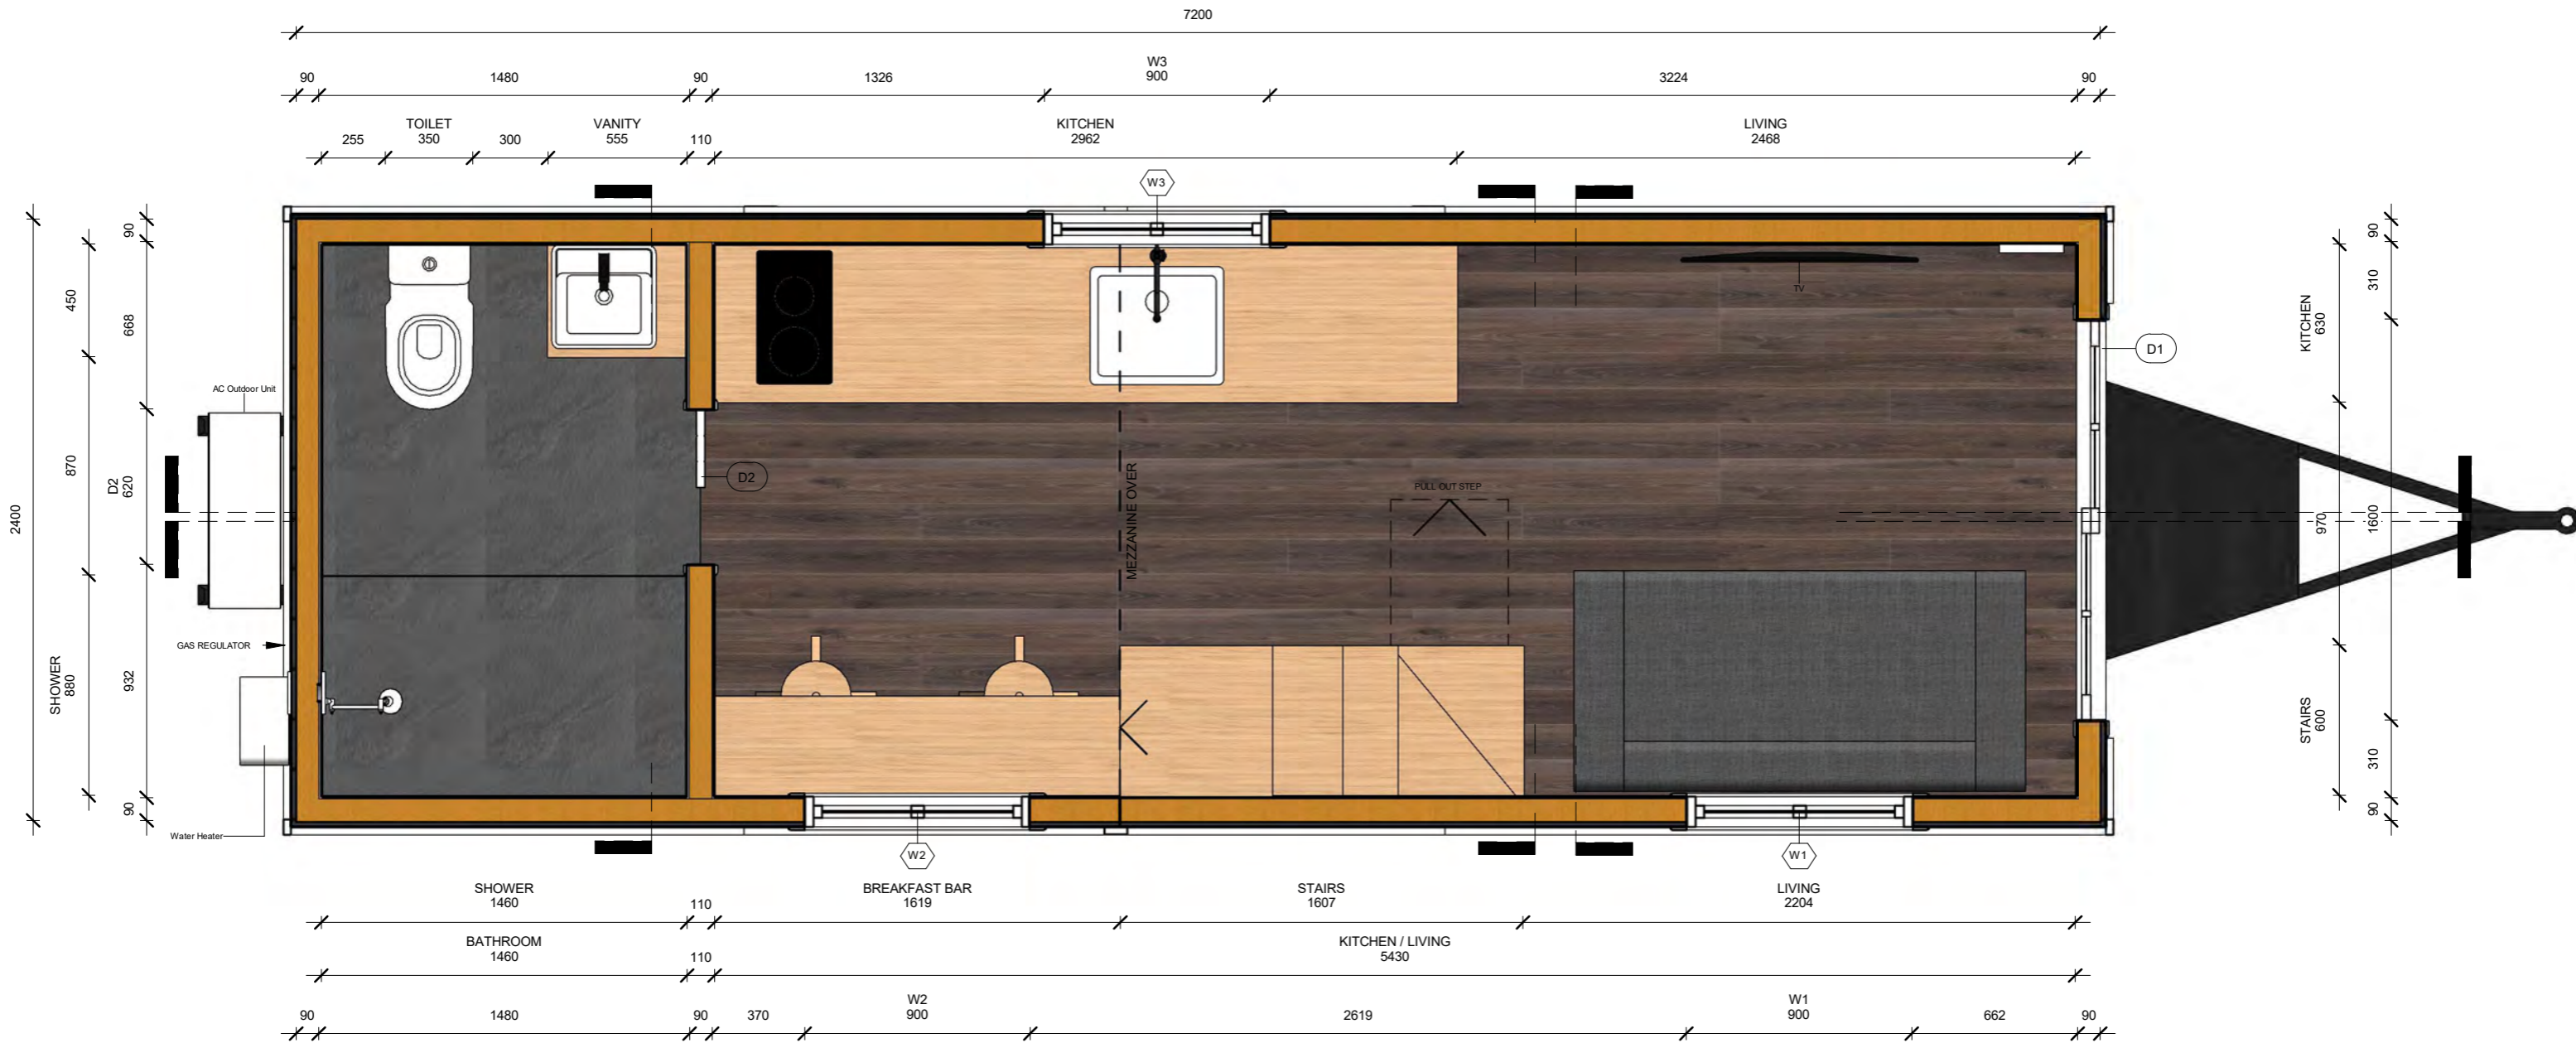


THE HILLSIDE 7200

DRAWING TITLE			SCALE	SHEET
FIRST LEVEL			1 : 25	A4
DRAWN BY	CHECKED BY	PROJECT N°	DATE	
FDLS		TheHillside7200_10-09-2020	10-09-2020	




1 MEZZANINE
1 : 25

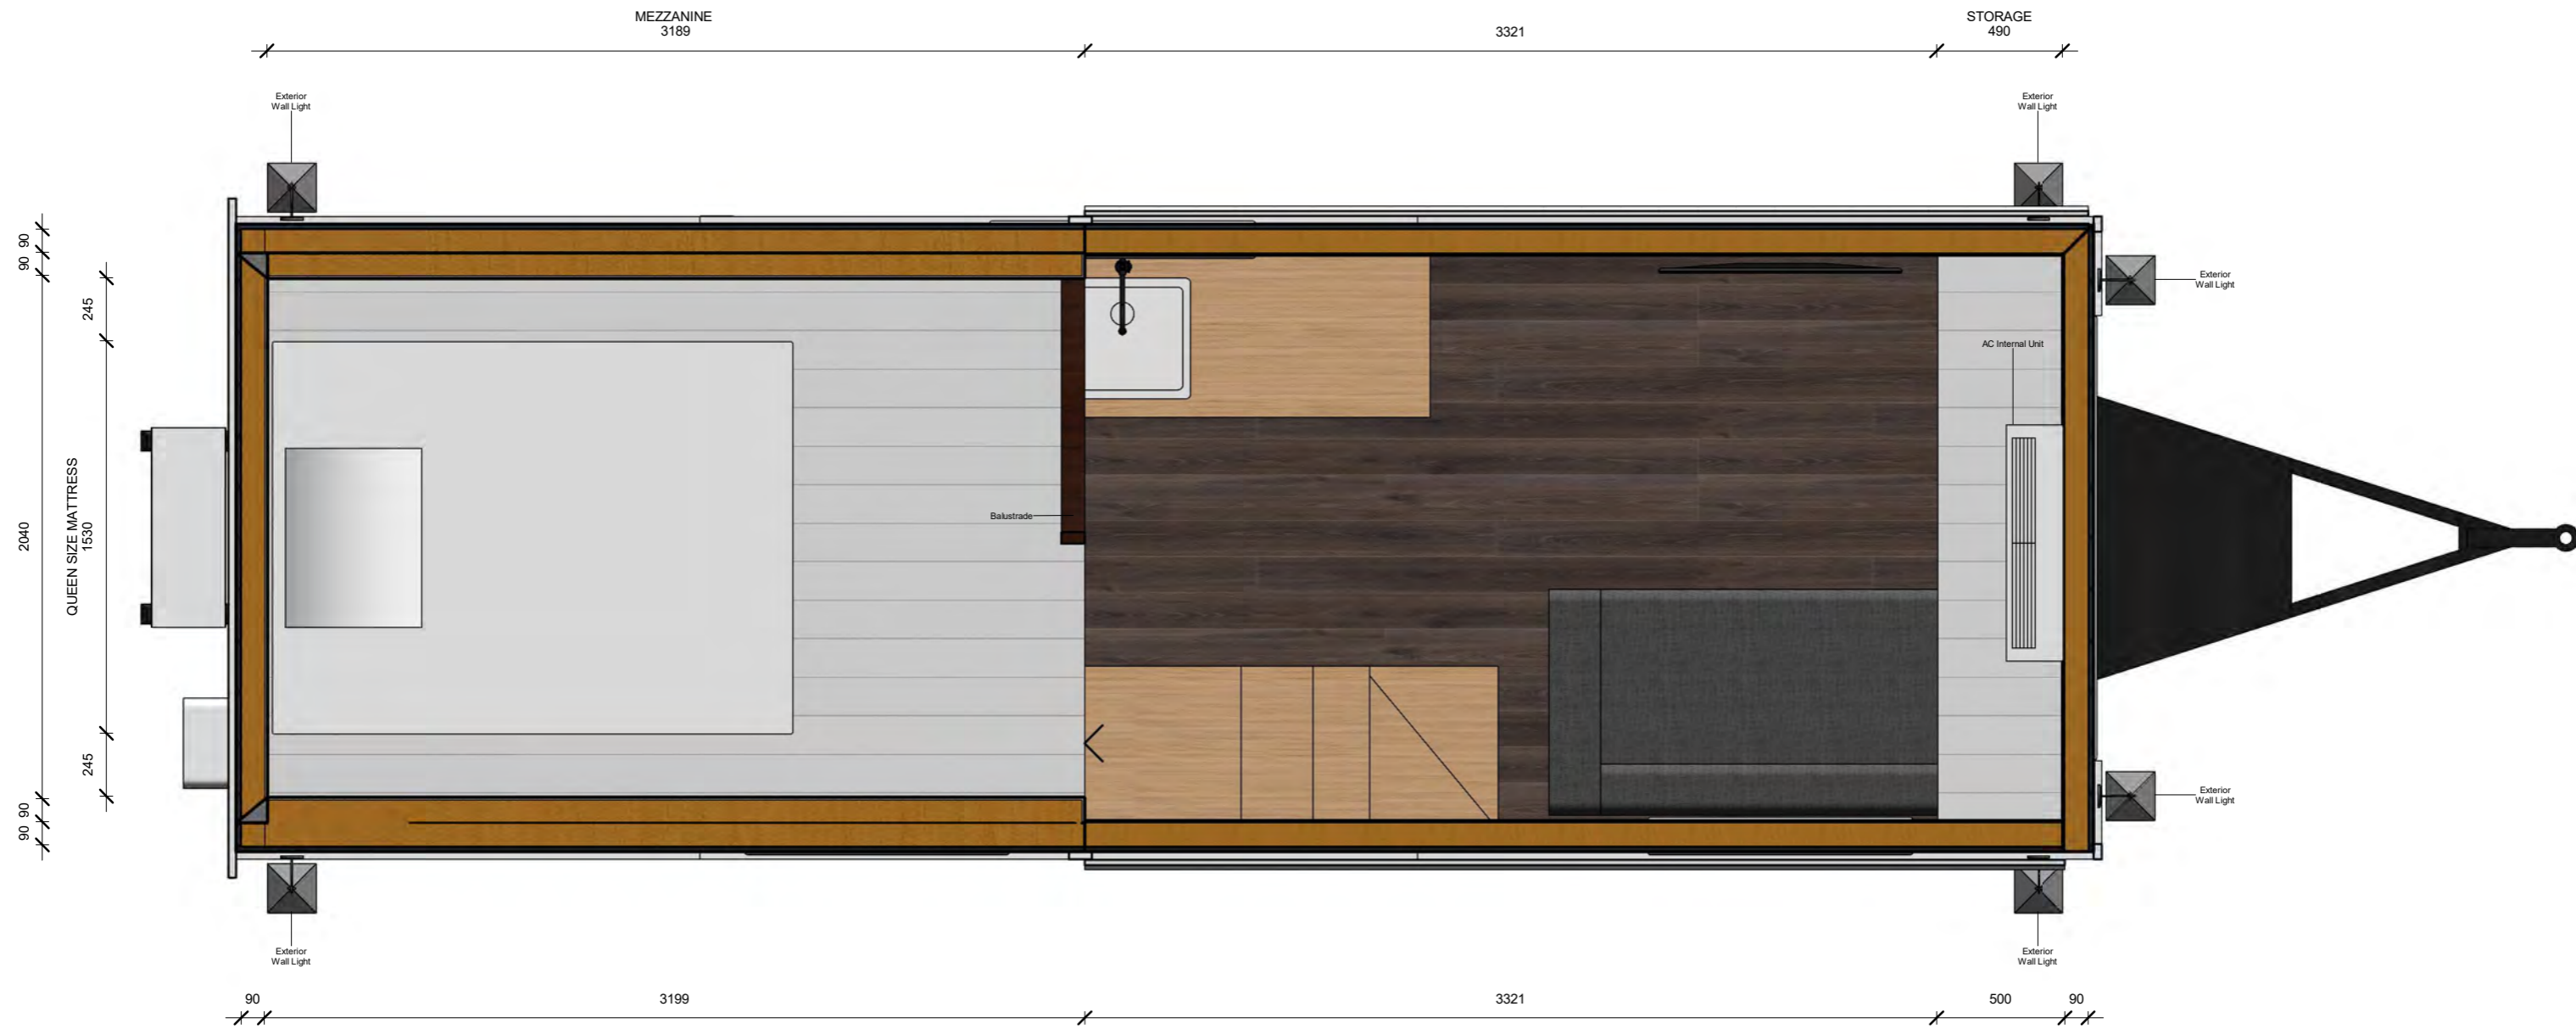

THE HILLSIDE 7200

DRAWING TITLE			SCALE	SHEET
MEZZANINE			1 : 25	A5
DRAWN BY	CHECKED BY	PROJECT N°	DATE	
FDLS		TheHillside7200_10-09-2020	10-09-2020	



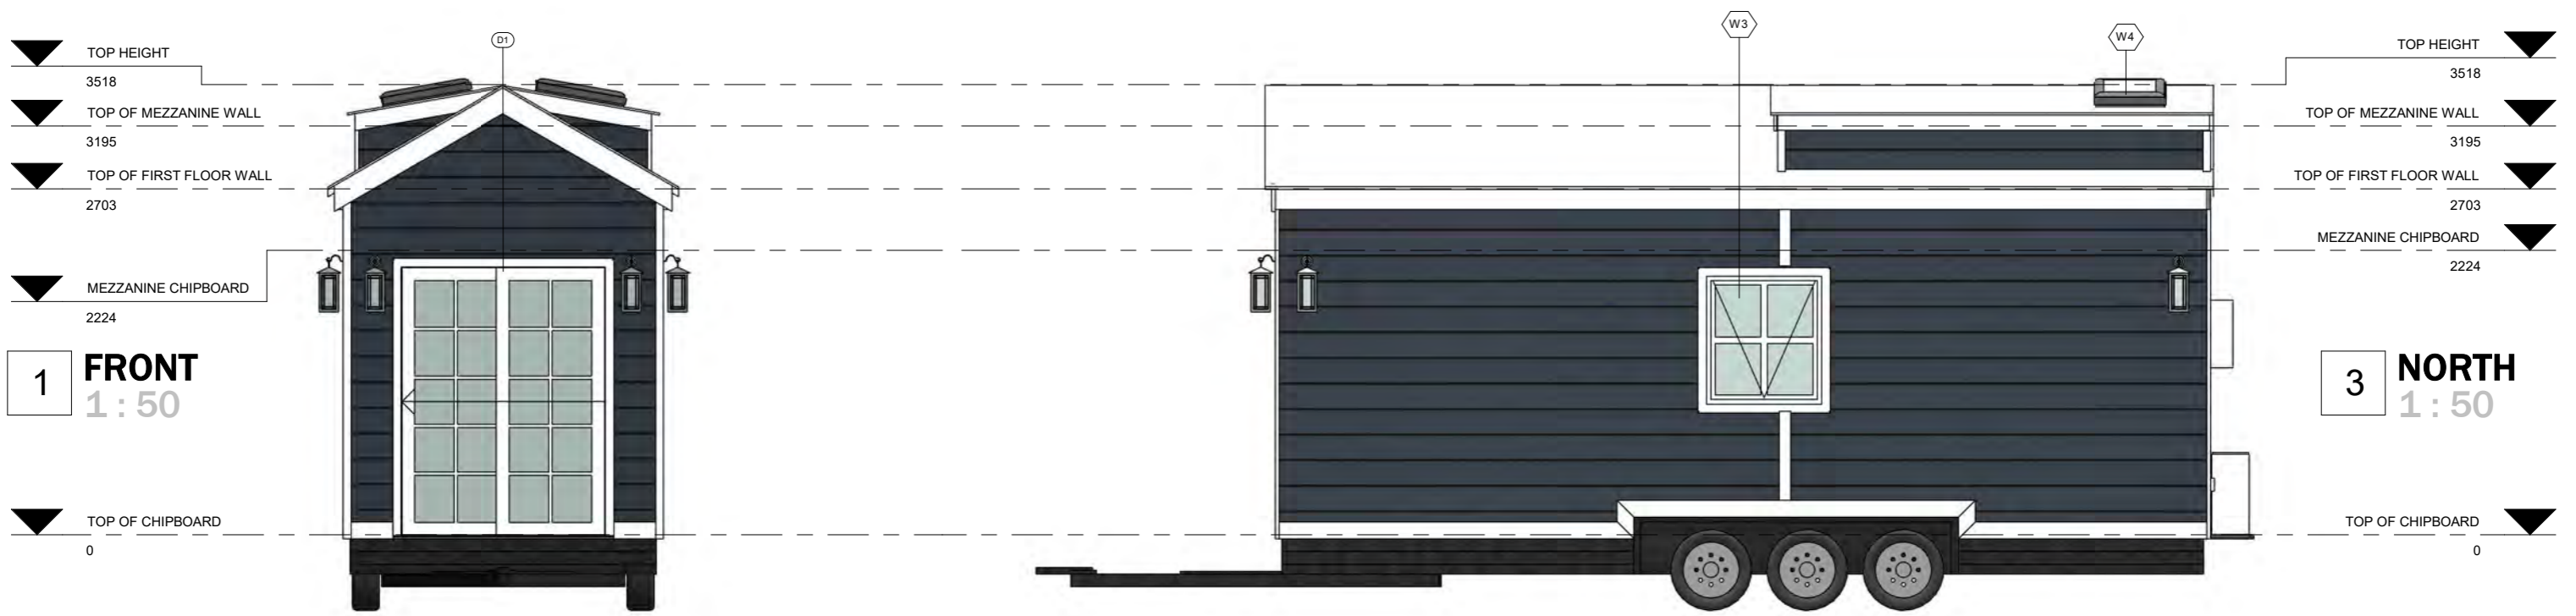

WINDOWS SCHEDULE

MARK	LOCATION	DESCRIPTION	WIDTH	HEIGHT	LEVEL	SILL HEIGHT	MATERIAL	GLAZING	INCLUDE FLYSCREENS	COMMENTS
W1	Living Room	Awning	900	1000	TOP OF CHIPBOARD	1031	Timber	Single	Yes	
W2	Breakfast Bar	Awning	900	1000	TOP OF CHIPBOARD	1031	Timber	Single	Yes	
W3	Kitchen	Awning	900	1000	TOP OF CHIPBOARD	1031	Timber	Single	Yes	
W4	Bedroom	Fixed Skylight	567	720	TOP OF MEZZANINE WALL		Aluminium	Double		
W5	Bedroom	Fixed Skylight	567	720	TOP OF MEZZANINE WALL		Aluminium	Double		


DOOR SCHEDULE

MARK	DESCRIPTION	MATERIAL	HEIGHT	WIDTH	DOOR REVEAL WIDTH	COMMENTS
D1	Sliding Door (Double, Colonial Style)	Timber (Natural), Glass	2100	1600		
D2	Cavity Slider, MDF Routed Panel	Timber (Natural), Glass	2000	620		

THE HILLSIDE 7200

DRAWING TITLE			SCALE	SHEET
ELEVATIONS			1 : 50	A6
DRAWN BY	CHECKED BY	PROJECT N°	DATE	
FDLS		TheHillside7200_10-09-2020	10-09-2020	



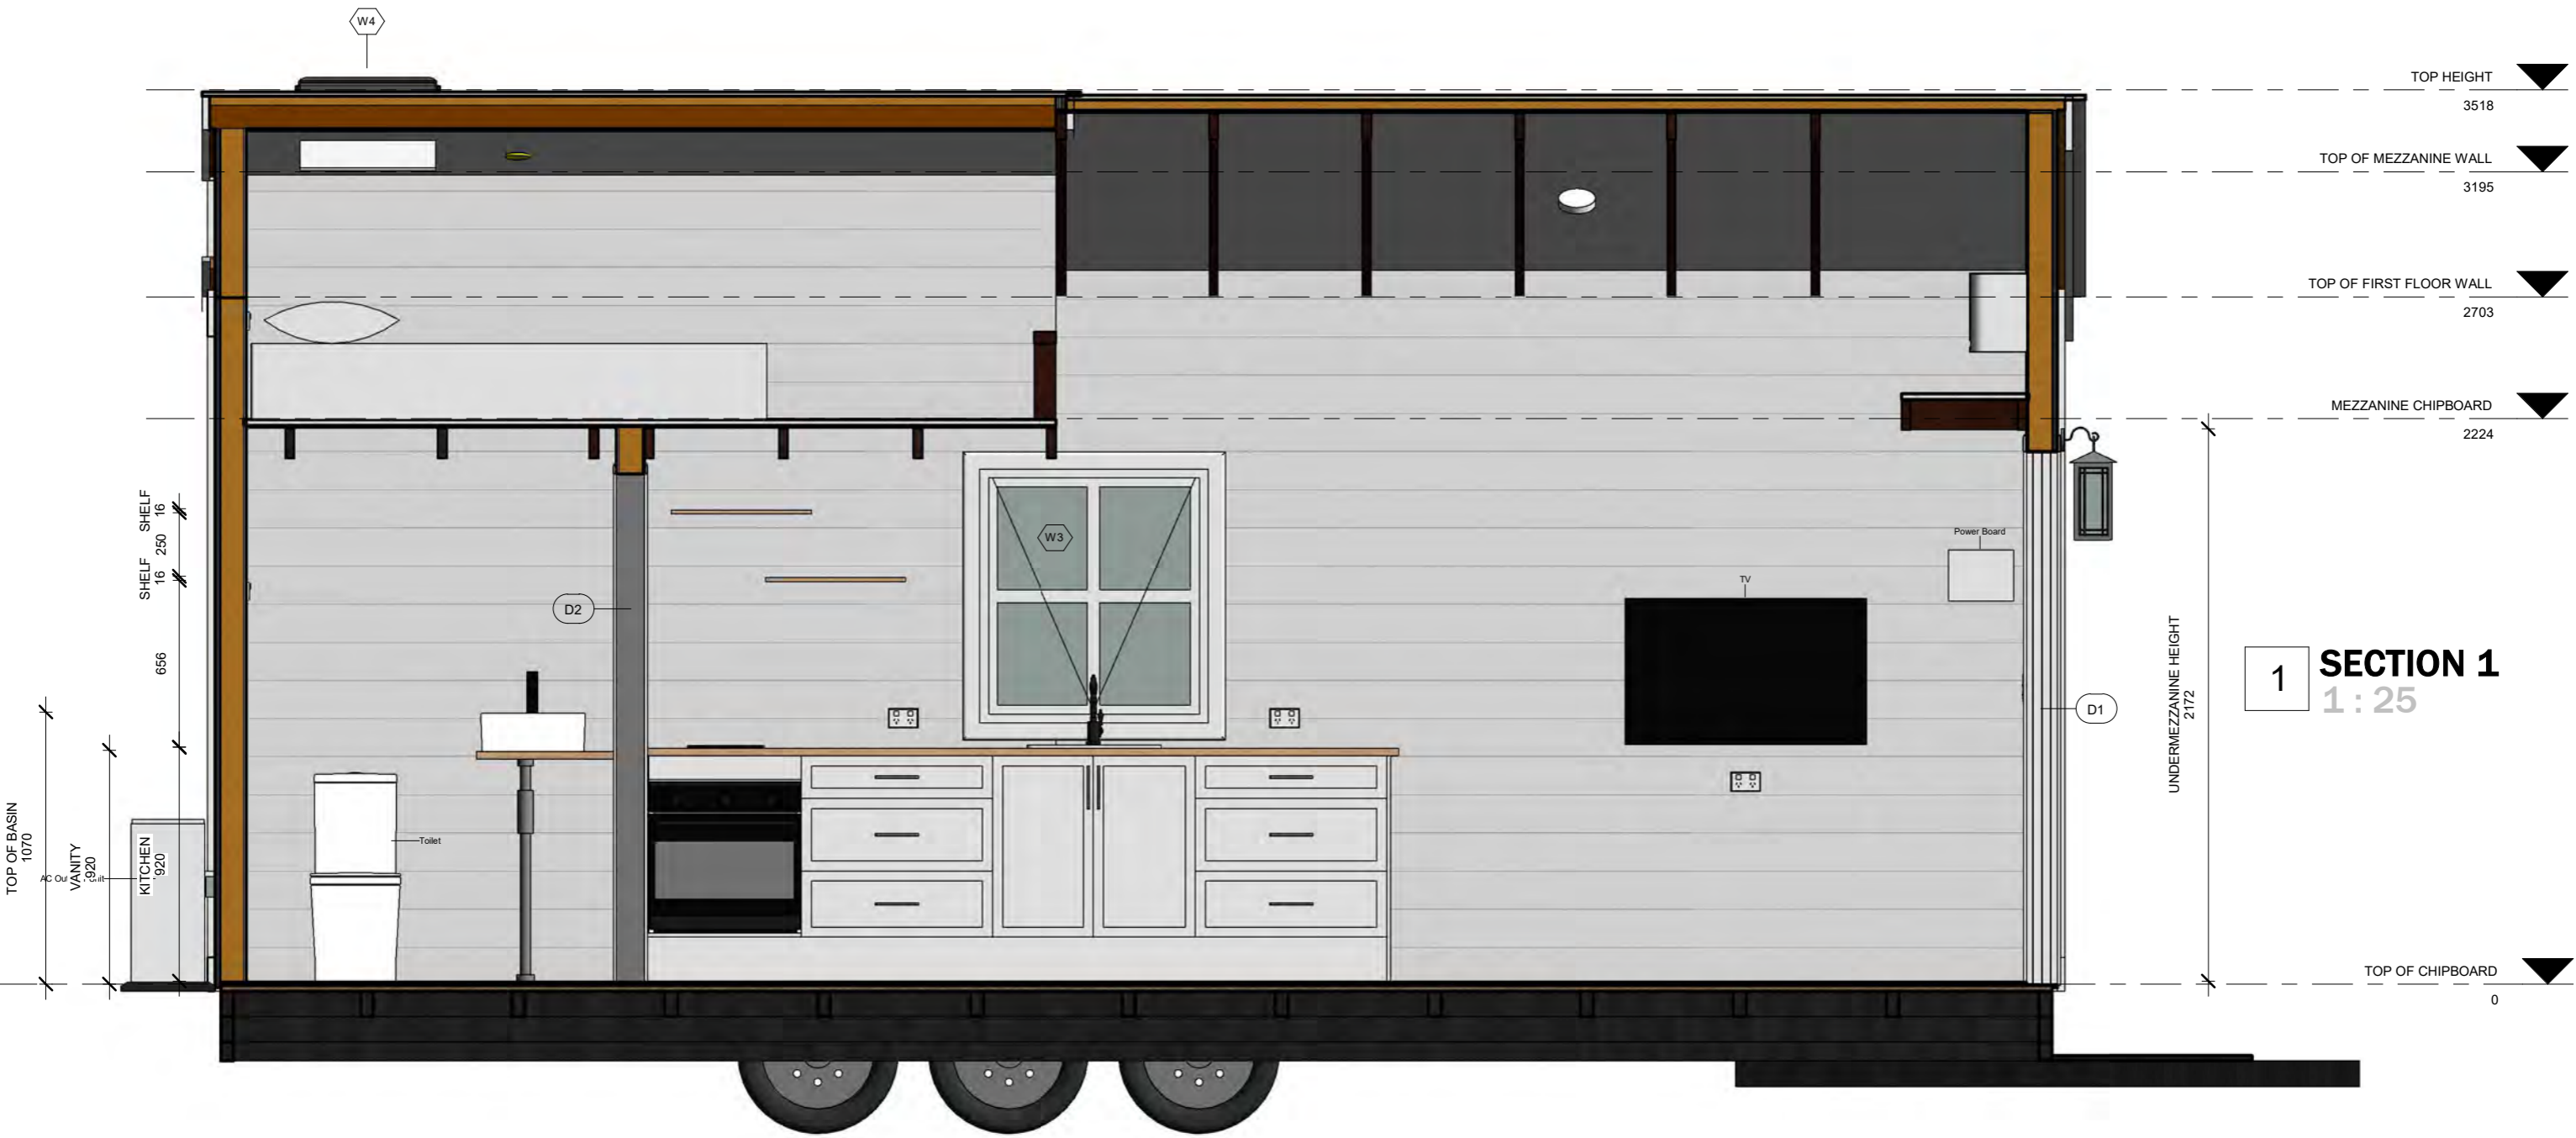

1 SECTION 1
1:25


THE HILLSIDE 7200

DRAWING TITLE			SCALE	SHEET
SECTION 1			1:25	A7
DRAWN BY	CHECKED BY	PROJECT N°	DATE	
FDLS		TheHillside7200_10-09-2020	10-09-2020	



1 SECTION 2
1 : 25


2 SECTION 3
1 : 25

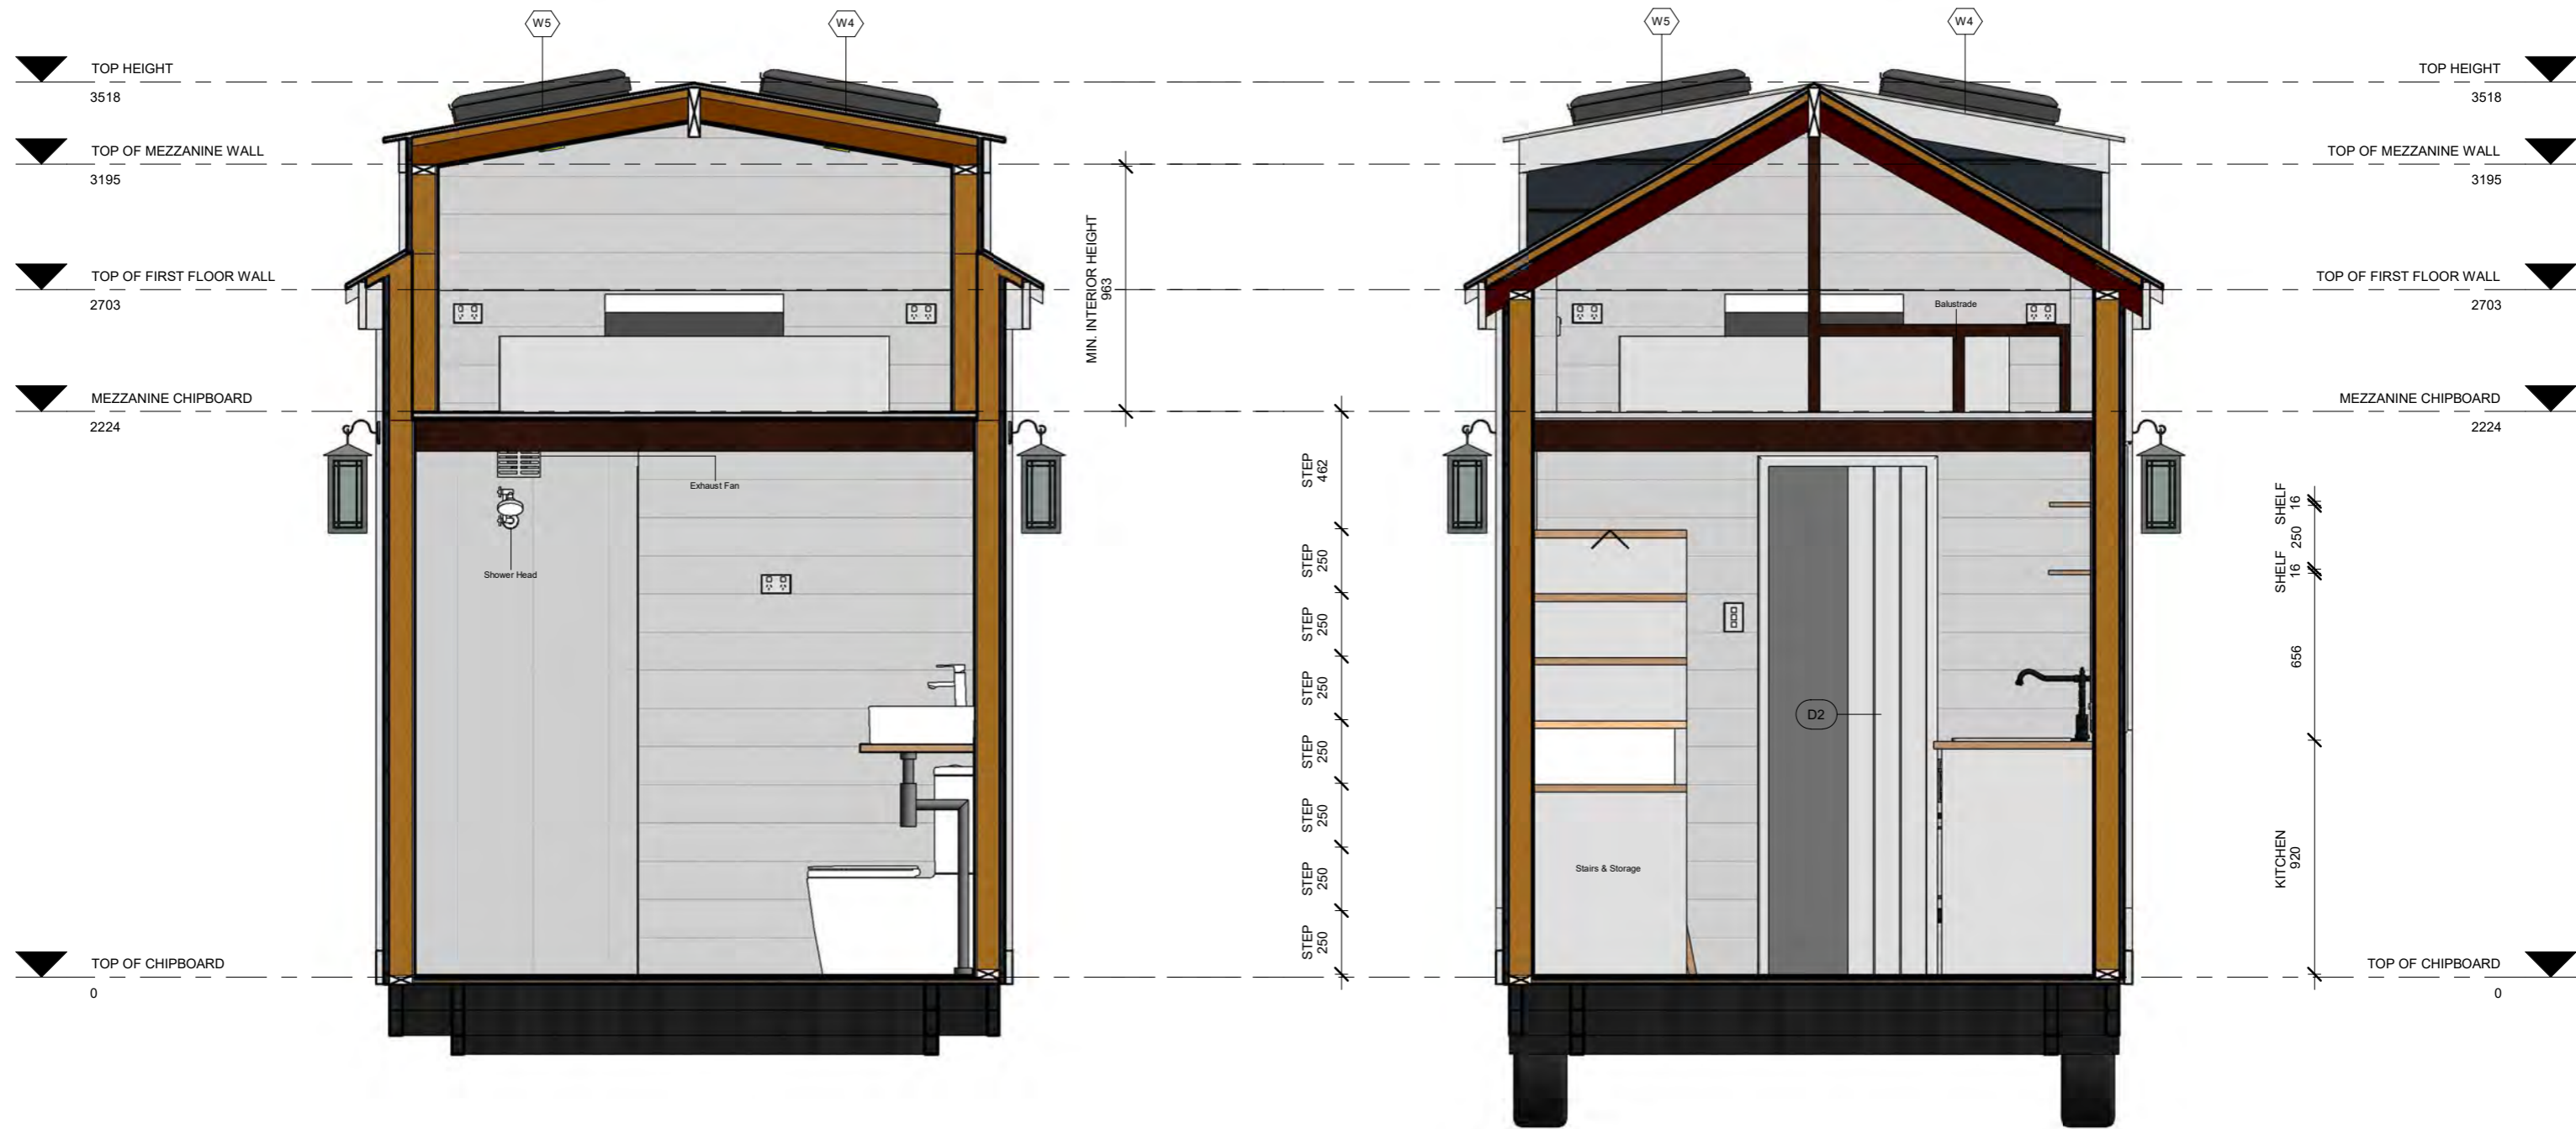

THE HILLSIDE 7200

DRAWING TITLE			SCALE	SHEET	
SECTION 2 & 3			1 : 25	A8	
DRAWN BY	CHECKED BY	PROJECT N°	DATE		
FDLS		TheHillside7200_10-09-2020	10-09-2020		

3 SECTION 4
1 : 25

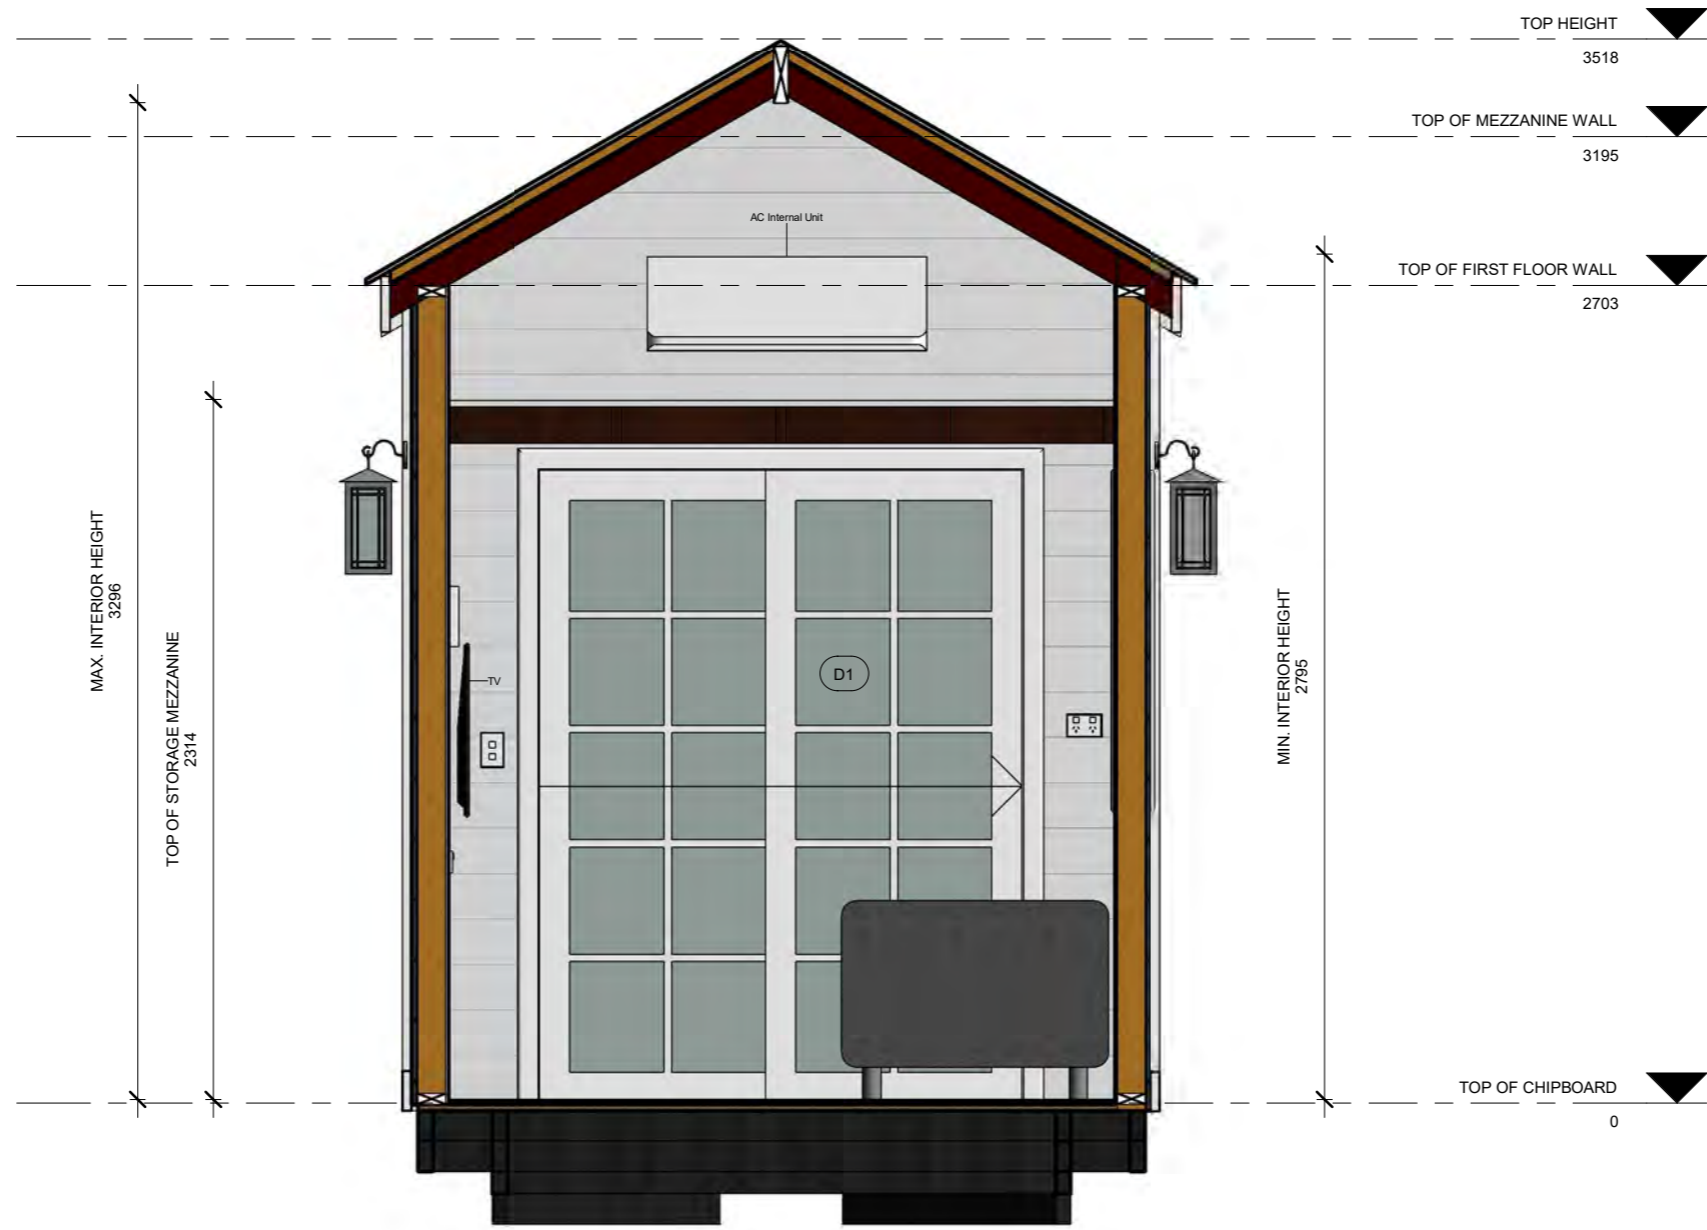

THE HILLSIDE 7200


DRAWING TITLE			SCALE	SHEET
SECTION 4			1 : 25	A9
DRAWN BY	CHECKED BY	PROJECT N°	DATE	
FDLS		TheHillside7200_10-09-2020	10-09-2020	



4 SECTION 5
1:25

BREAKFAST BAR
920

D1

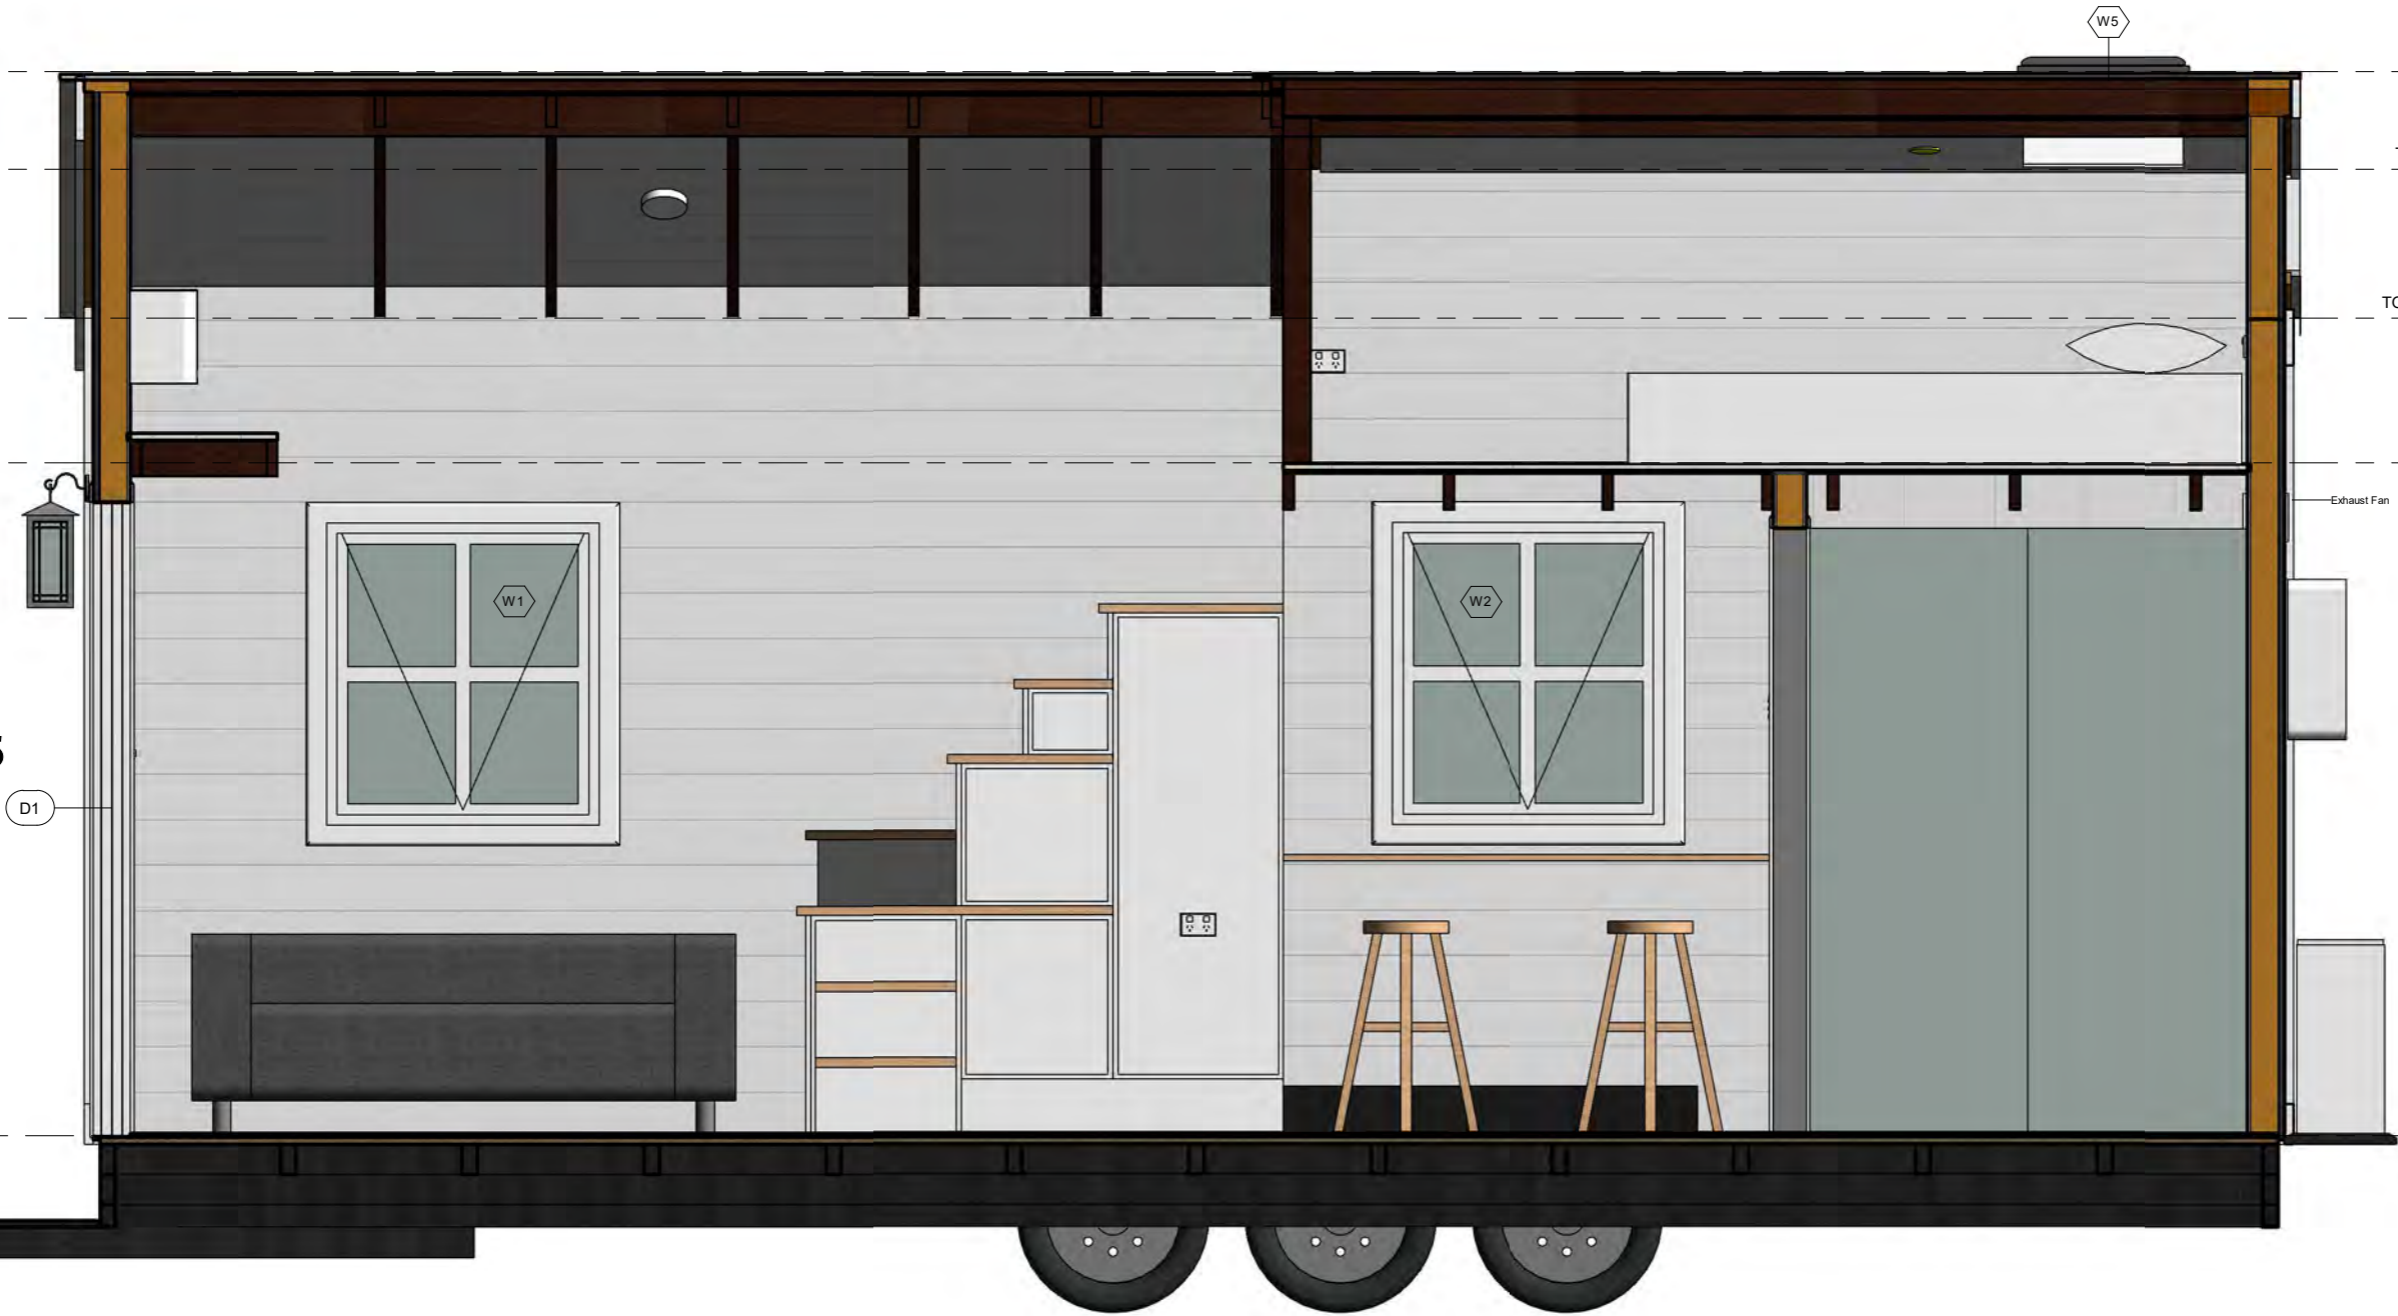

TOP HEIGHT
3518

TOP OF MEZZANINE WALL
3195

TOP OF FIRST FLOOR WALL
2703

MEZZANINE CHIPBOARD
2224

TOTAL BATHROOM INTERIOR HEIGHT
2180


TOP OF CHIPBOARD
0

STEPS 500 PIGEON HOLE 500 FRIDGE CABINET 545

THE HILLSIDE 7200

DRAWING TITLE			SCALE	SHEET
SECTION 5			1:25	A10
DRAWN BY	CHECKED BY	PROJECT N°	DATE	
FDLS		TheHillside7200_10-09-2020	10-09-2020	



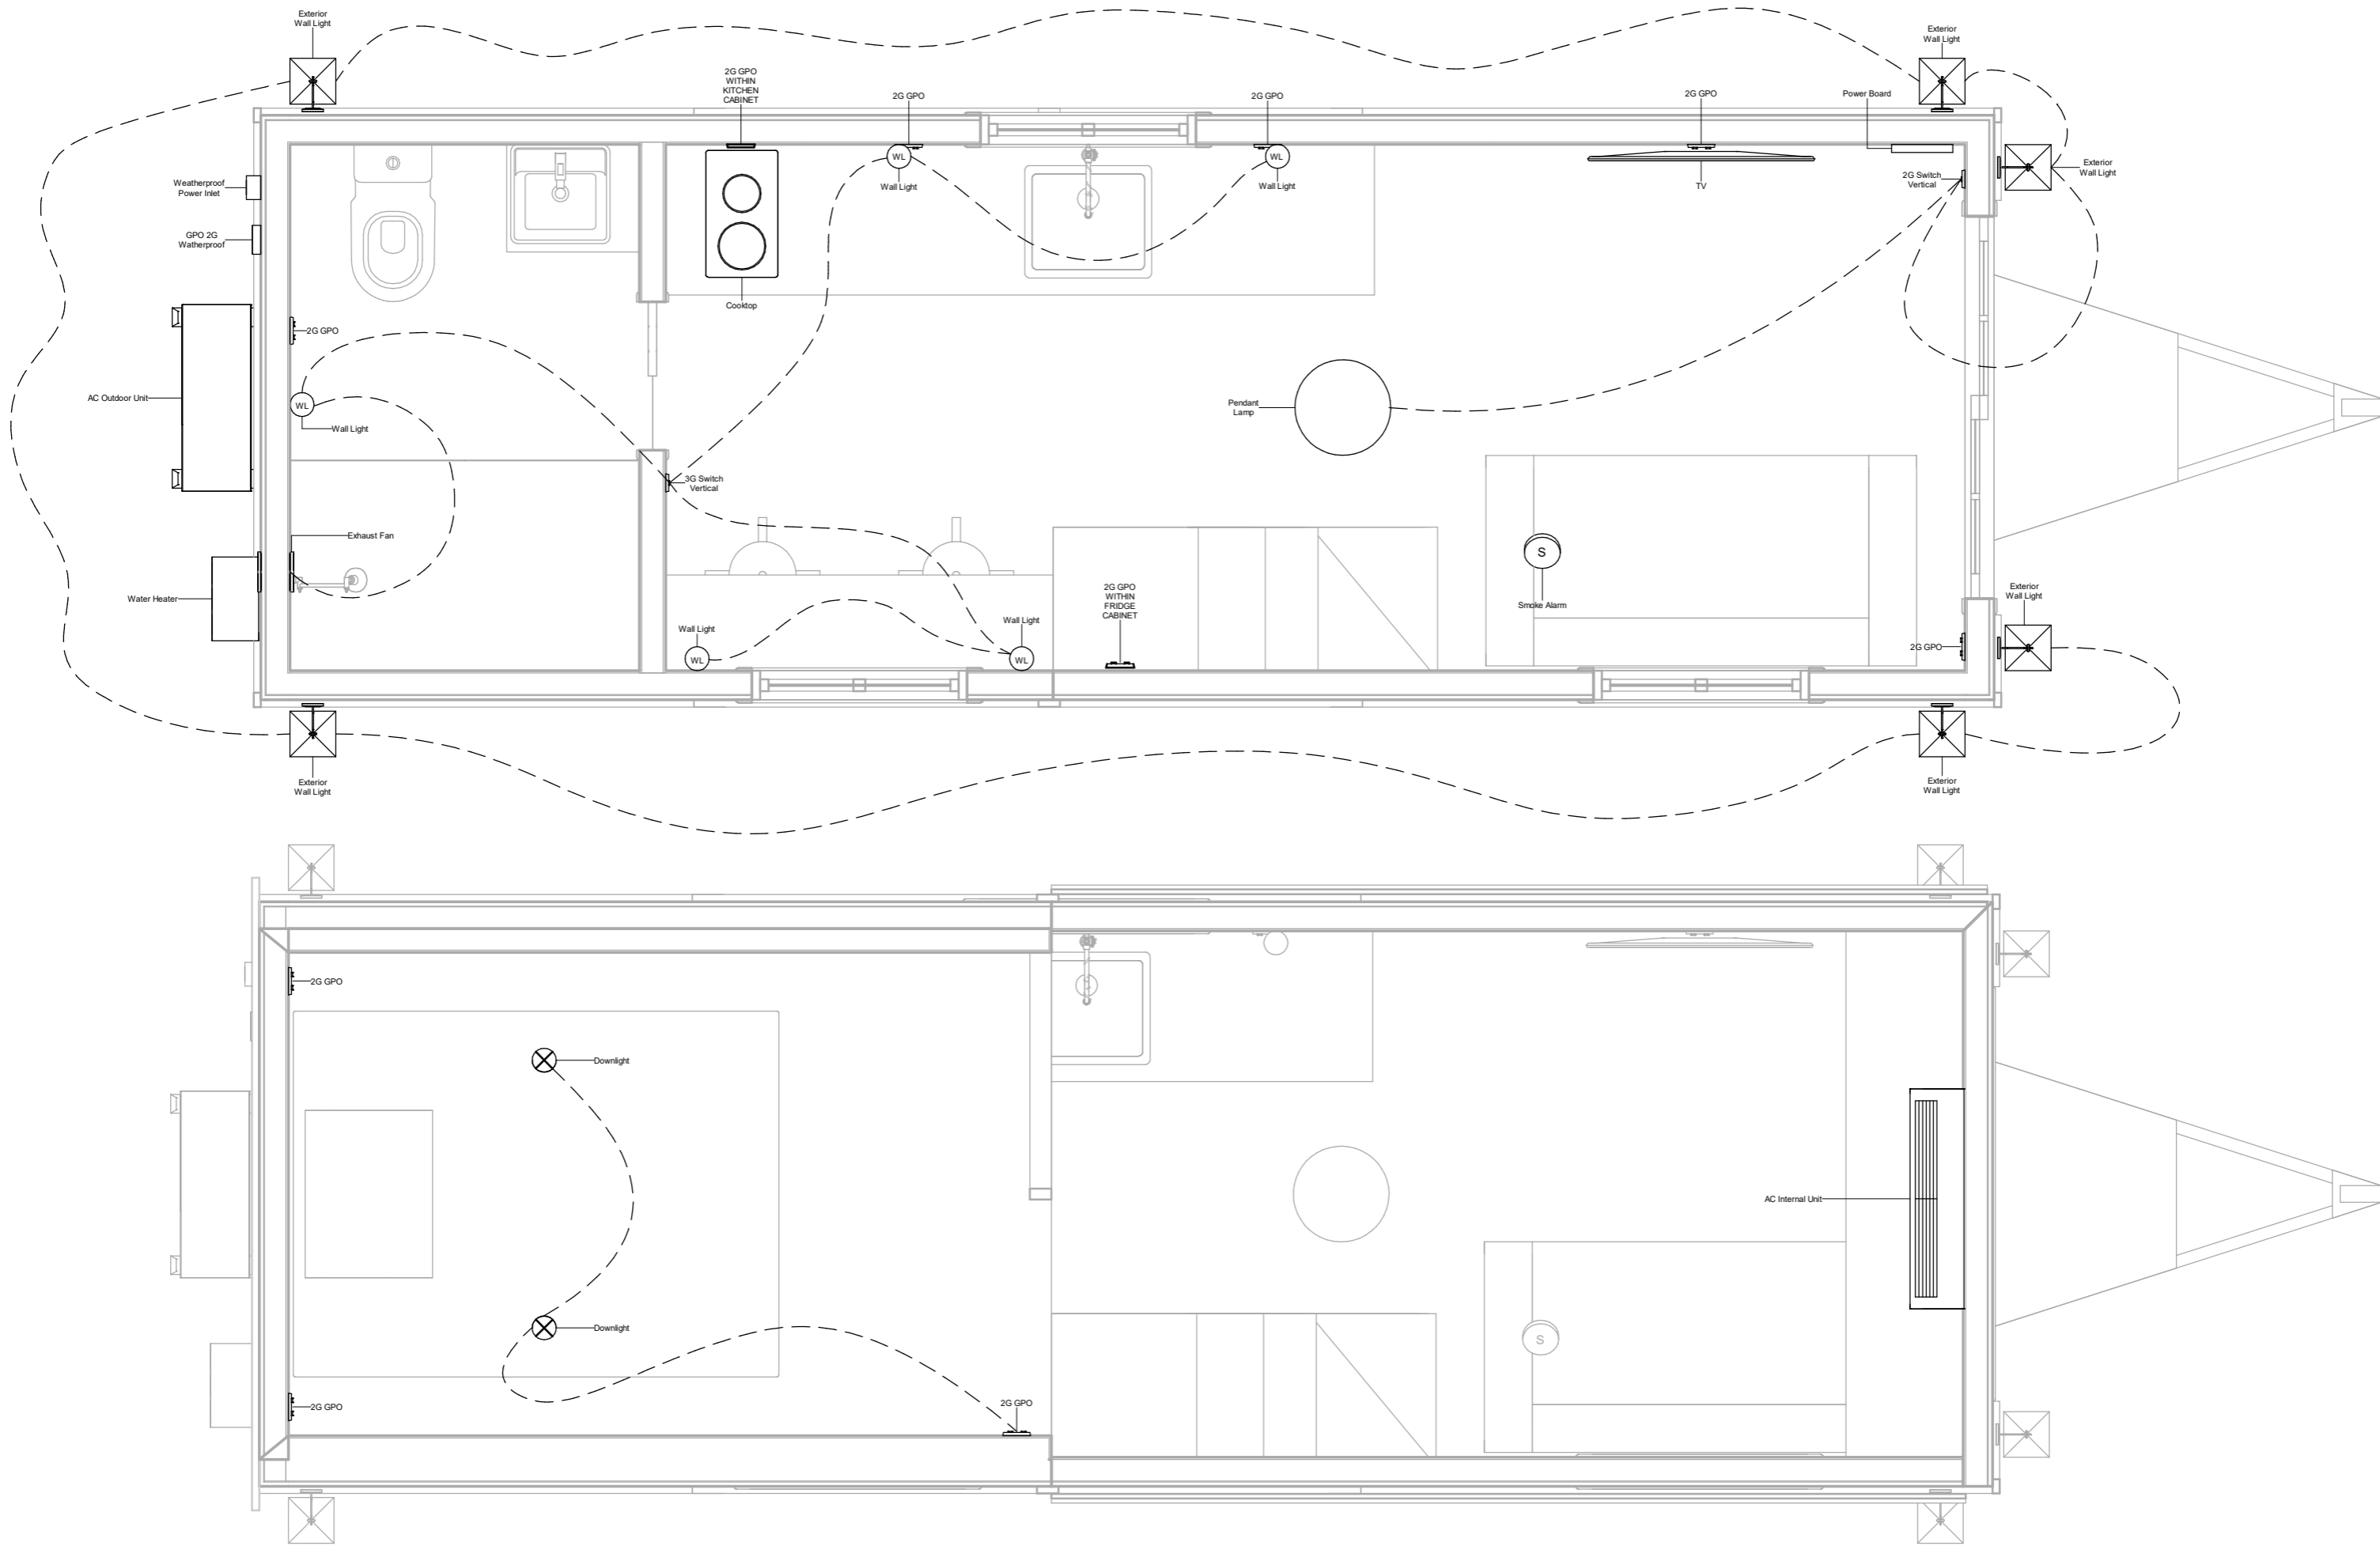

THE HILLSIDE 7200

DRAWING TITLE			SCALE	SHEET
ELECTRICAL PLANS			1 : 25	A12
DRAWN BY	CHECKED BY	PROJECT N°	DATE	
FDLS		TheHillside7200_10-09-2020	10-09-2020	

