

THE TINY TRAVELLER

DRAWING TITLE			SCALE	SHEET
EXTERIOR VIEWS				A01
DRAWN BY	CHECKED BY	PROJECT N°	DATE	
FDLS		TheTinyTraveller	09-11-2020	





THE TINY TRAVELLER

DRAWING TITLE			SCALE	SHEET
INTERIOR VIEWS				A02
DRAWN BY	CHECKED BY	PROJECT N°	DATE	
FDLS		TheTinyTraveller	09-11-2020	



1 ROOF
1 : 20

OVERHANG
150

OVERHANG
150




THE TINY TRAVELLER

DRAWING TITLE			SCALE	SHEET
ROOF PLAN			1 : 20	A03
DRAWN BY	CHECKED BY	PROJECT N°	DATE	
FDLS		TheTinyTraveller	09-11-2020	




1 TOP OF CHIPBOARD
1 : 20

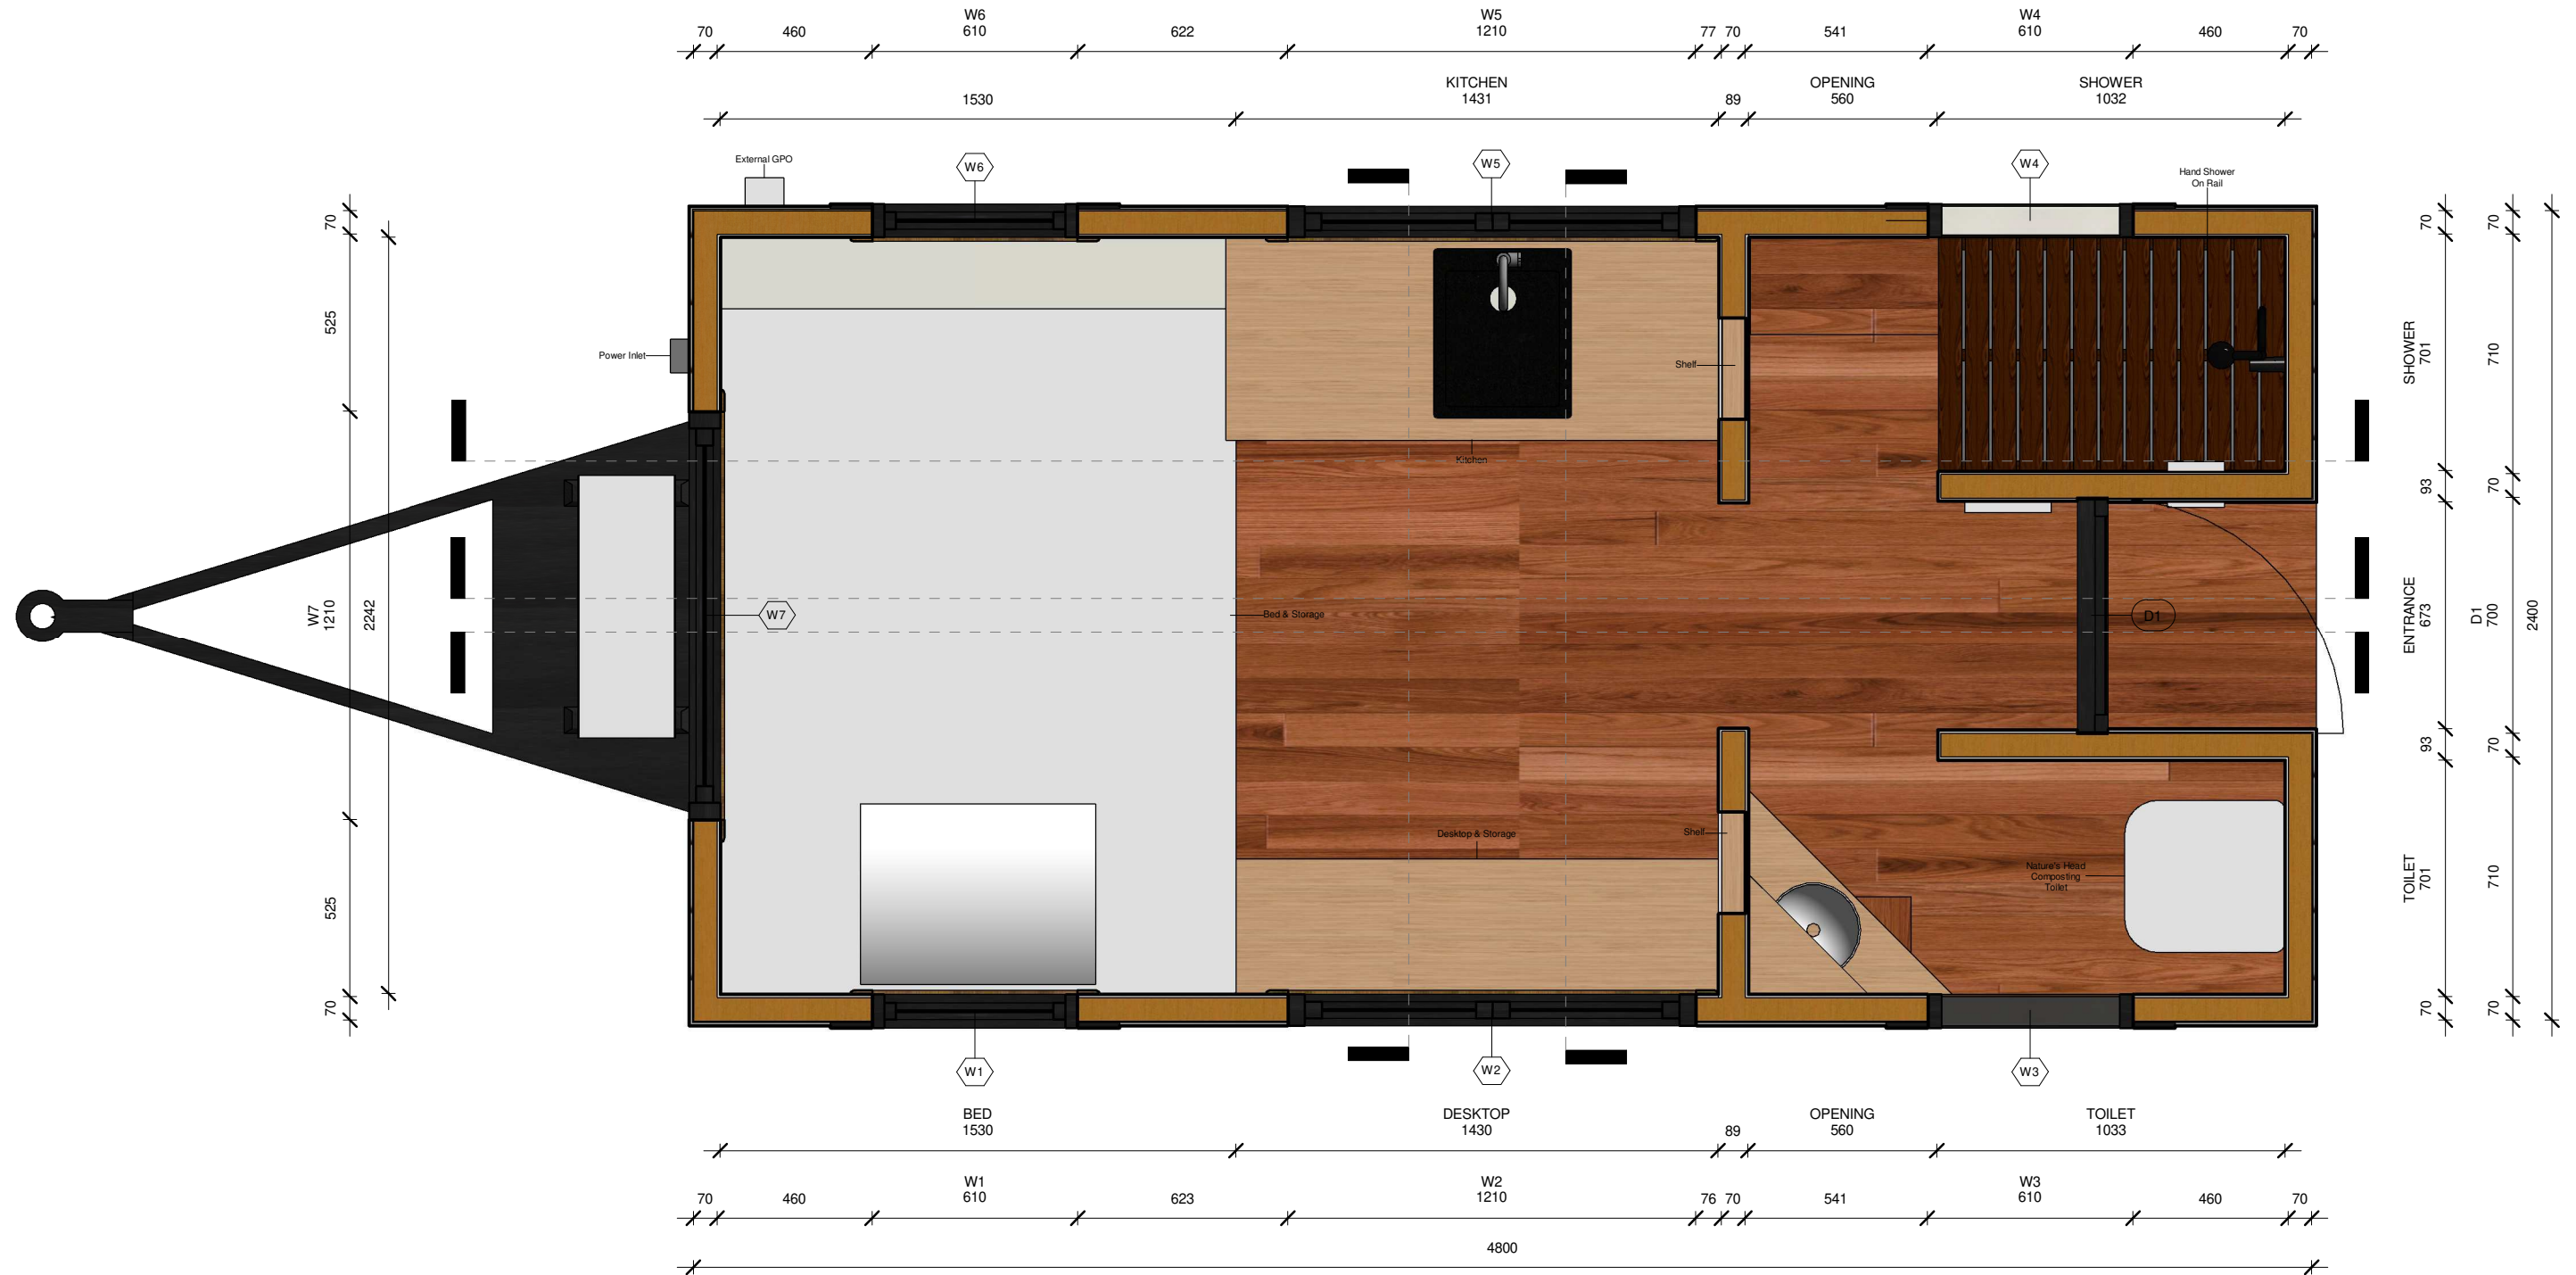

THE TINY TRAVELLER

DRAWING TITLE			SCALE	SHEET
FLOOR PLAN			1 : 20	A04
DRAWN BY	CHECKED BY	PROJECT N°	DATE	
FDLS		TheTinyTraveller	09-11-2020	



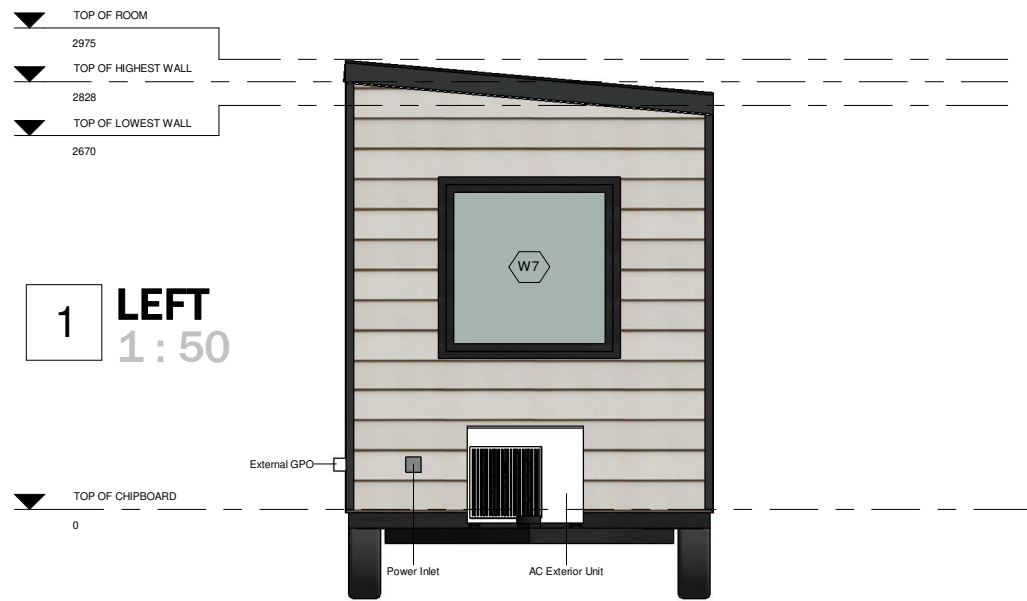

1 LEFT
1 : 50



2 FRONT
1 : 50



4 RIGHT
1 : 50



3 REAR
1 : 50

WINDOWS SCHEDULE

MARK	DESCRIPTION	HEIGHT	WIDTH	LEVEL	SILL HEIGHT	MATERIAL	GLAZING	COMMENTS
W1	Awning	1200	610	TOP OF CHIPBOARD	1006	Aluminium, Custom black	Single	Bradnams A1206
W2	Awning	1200	1210	TOP OF CHIPBOARD	1006	Aluminium, Custom black	Single	Bradnams AF1212
W3	Louvre	1200	610	TOP OF CHIPBOARD	1006	Aluminium, Custom black	Single	Frosted Glass
W4	Louvre	1200	610	TOP OF CHIPBOARD	1006	Aluminium, Custom black	Single	Frosted Glass
W5	Awning	1200	1210	TOP OF CHIPBOARD	1006	Aluminium, Custom black	Single	Bradnams AF1212
W6	Awning	1200	610	TOP OF CHIPBOARD	1006	Aluminium, Custom black	Single	Bradnams A1206
W7	Fixed	1200	1210	TOP OF CHIPBOARD	1006	Aluminium, Custom black	Single	

DOOR SCHEDULE

MARK	DESCRIPTION	MATERIAL	HEIGHT	WIDTH	COMMENTS
D1	Hinged, Single glass panel	Custom black	2100	700	

THE TINY TRAVELLER

DRAWING TITLE			SCALE	SHEET
ELEVATIONS			1 : 50	A06
DRAWN BY	CHECKED BY	PROJECT N°	DATE	
FDLS		TheTinyTraveller	09-11-2020	



1 SECTION 1
1 : 25



THE TINY TRAVELLER

DRAWING TITLE			SCALE	SHEET
SECTION 1			1 : 25	A07
DRAWN BY	CHECKED BY	PROJECT N°	DATE	
FDLS		TheTinyTraveller	09-11-2020	



1 SECTION 2
1 : 25




THE TINY TRAVELLER

DRAWING TITLE			SCALE	SHEET
SECTION 2			1 : 25	A08
DRAWN BY	CHECKED BY	PROJECT N°	DATE	
FDLS		TheTinyTraveller	09-11-2020	



1 SECTION 3
1 : 25


2 SECTION 4
1 : 25

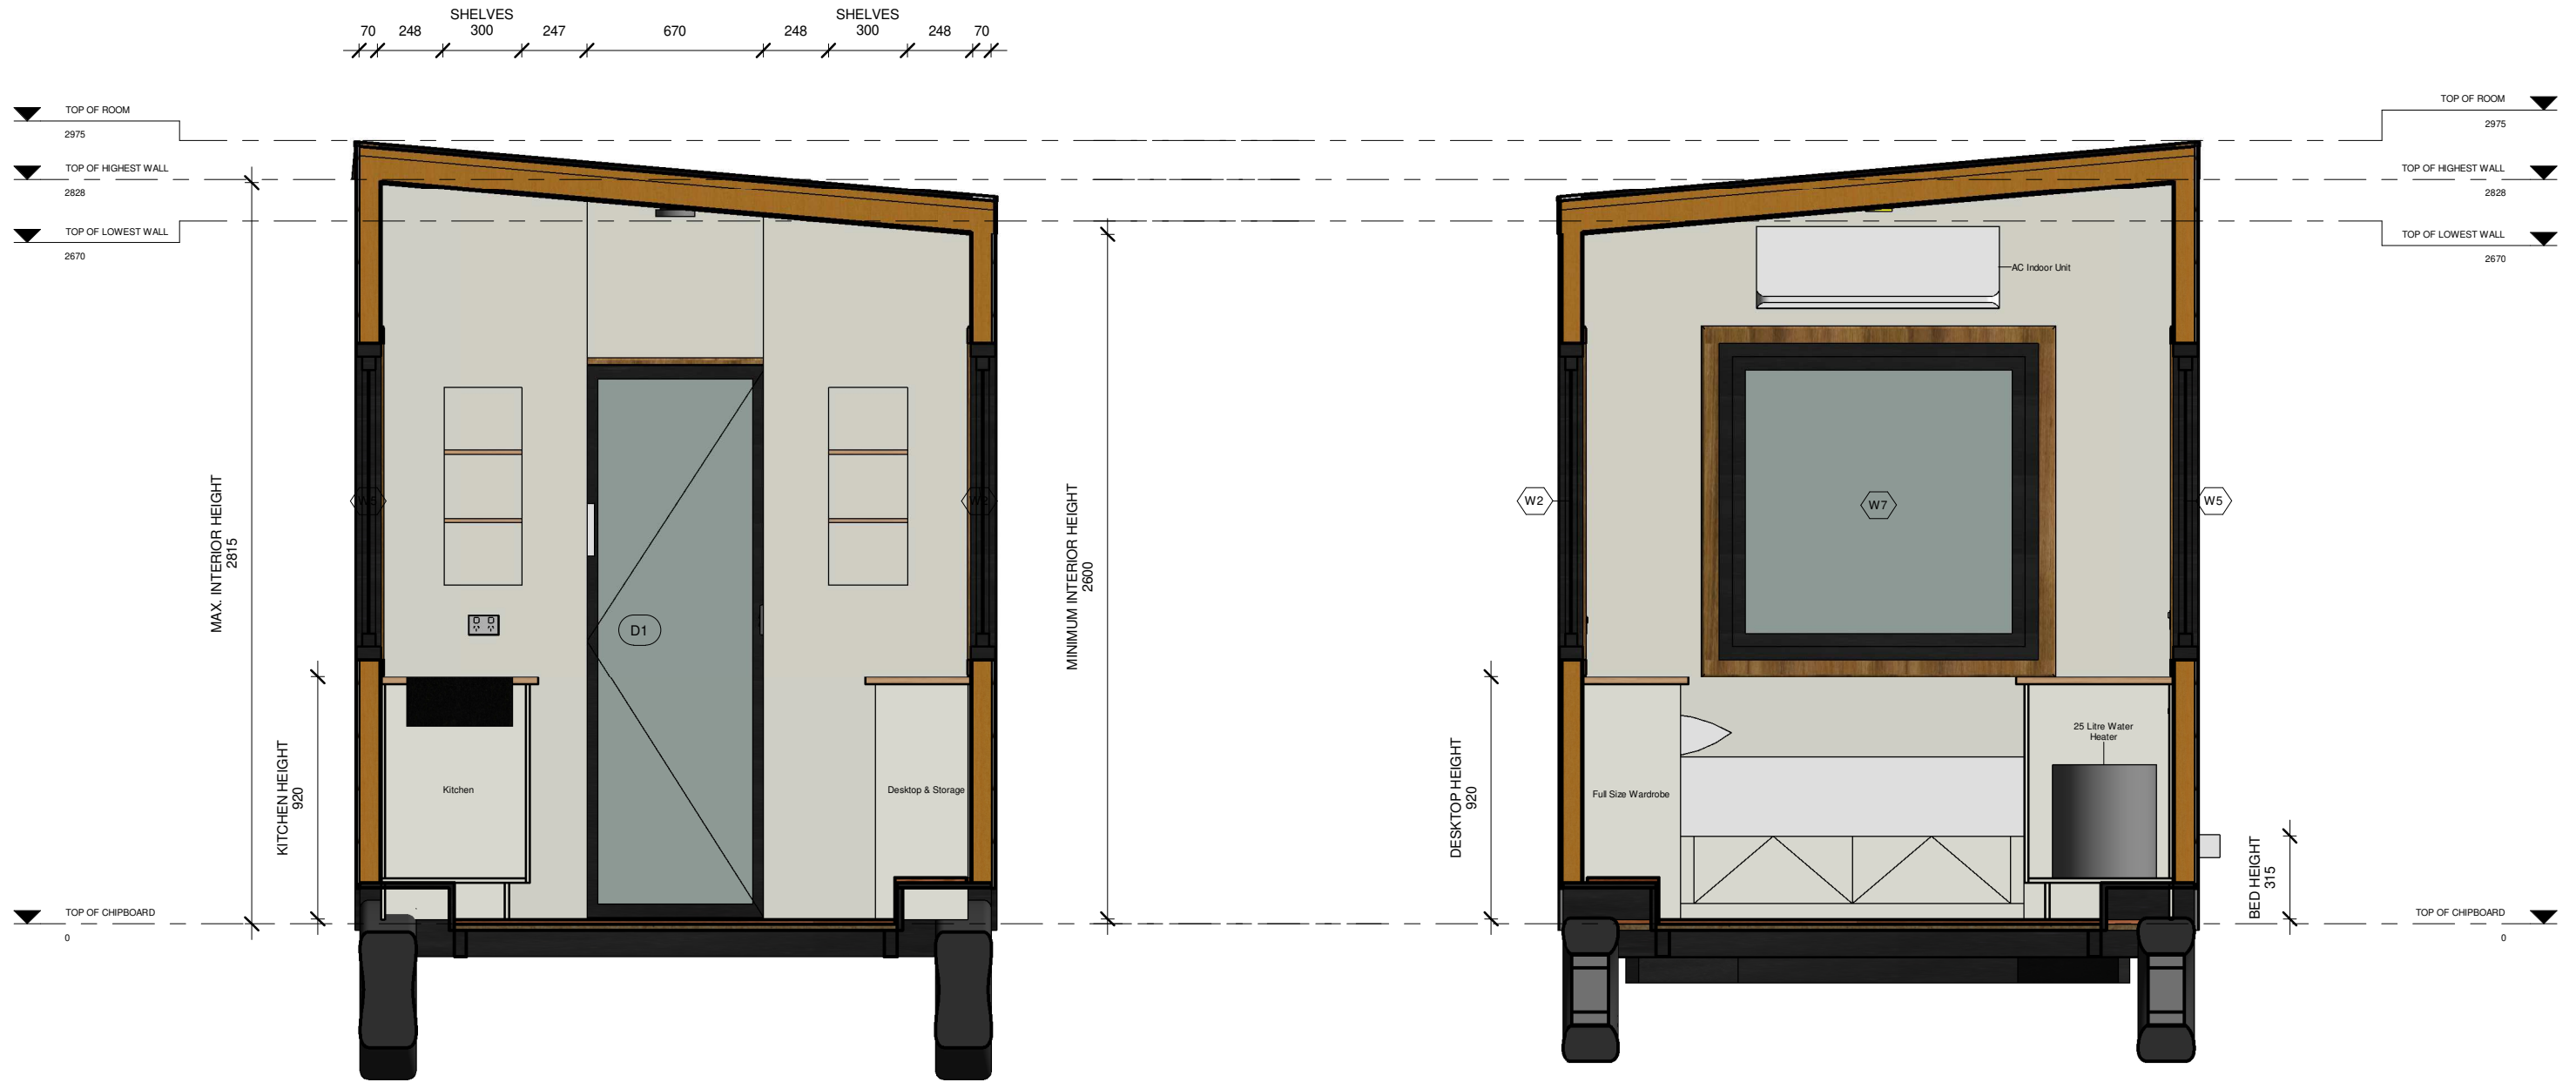

THE TINY TRAVELLER

DRAWING TITLE			SCALE	SHEET
SECTION 3 & 4			1 : 25	A09
DRAWN BY	CHECKED BY	PROJECT N°	DATE	
FDLS		TheTinyTraveller	09-11-2020	



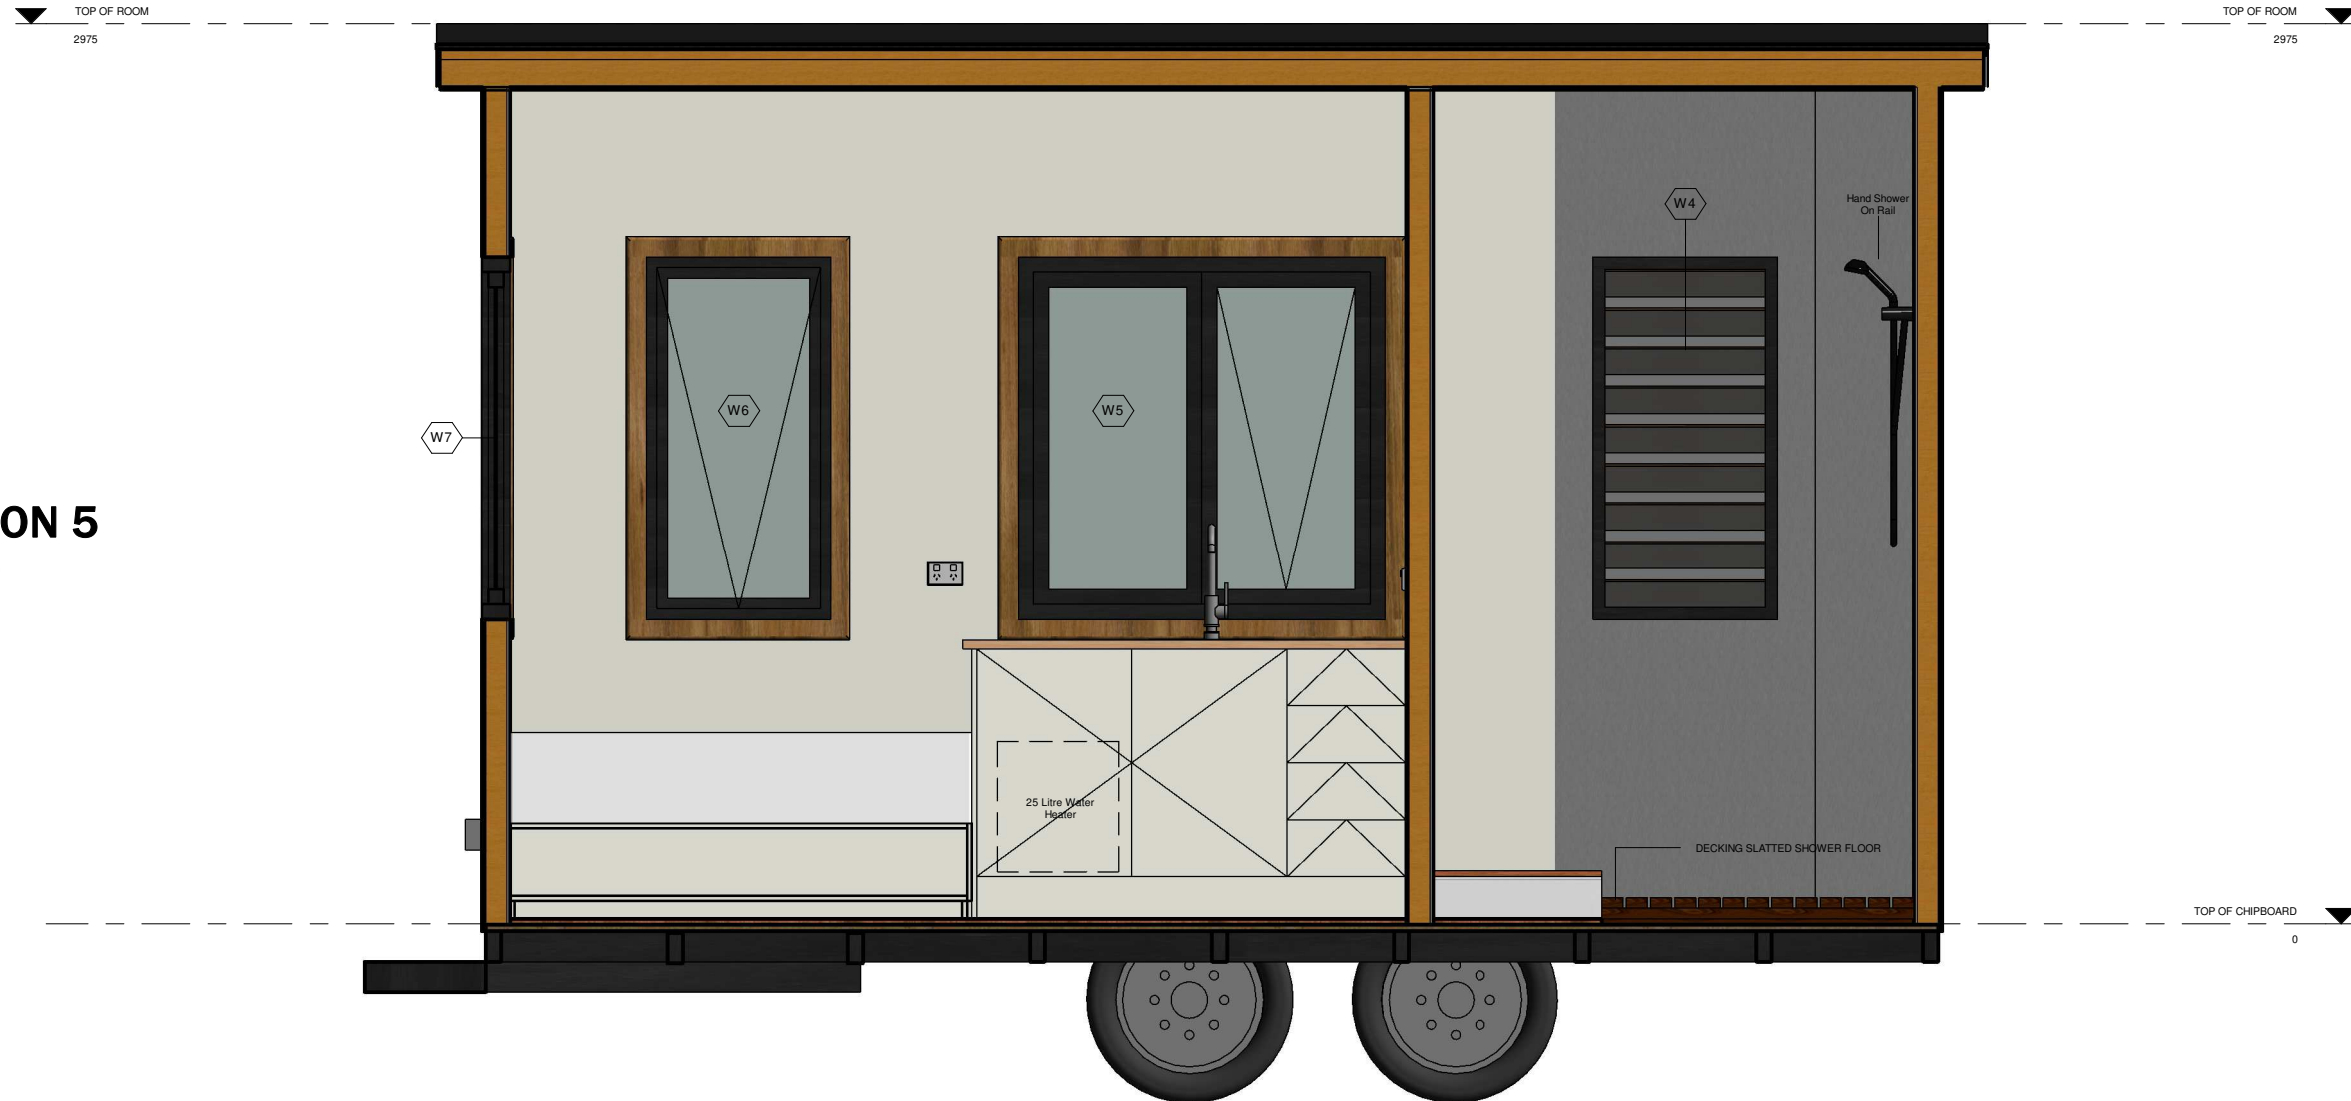


1 SECTION 5
1 : 25

THE TINY TRAVELLER


DRAWING TITLE			SCALE	SHEET
SECTION 5			1 : 25	A10
DRAWN BY	CHECKED BY	PROJECT N°	DATE	
FDLS		TheTinyTraveller	09-11-2020	



1 TRAILER PLAN
1 : 20

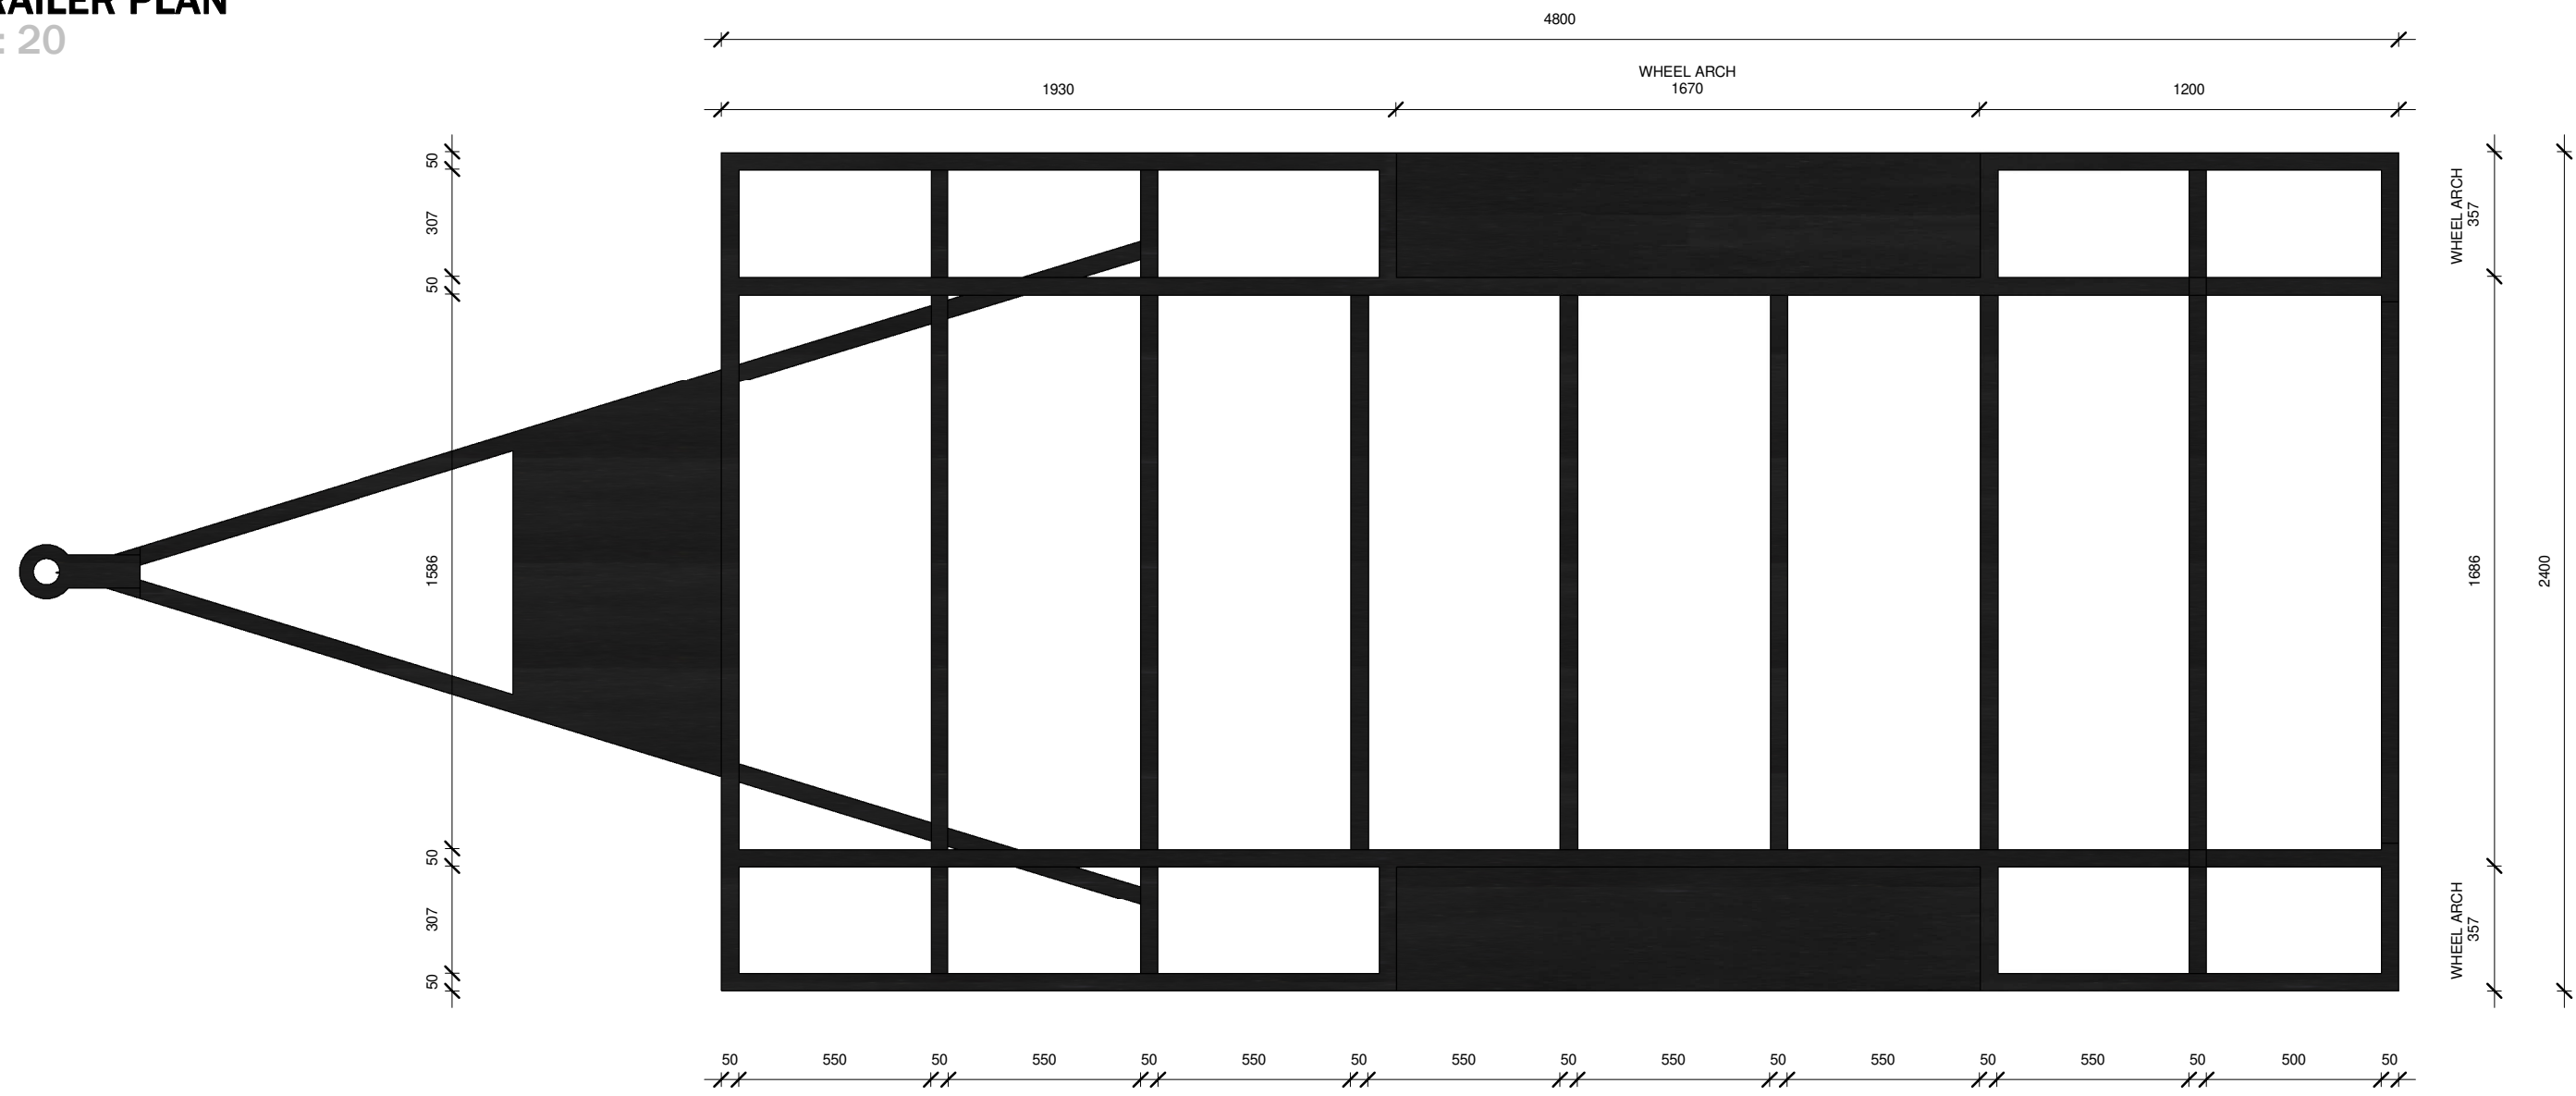

2 TRAILER ELEVATION
1 : 20

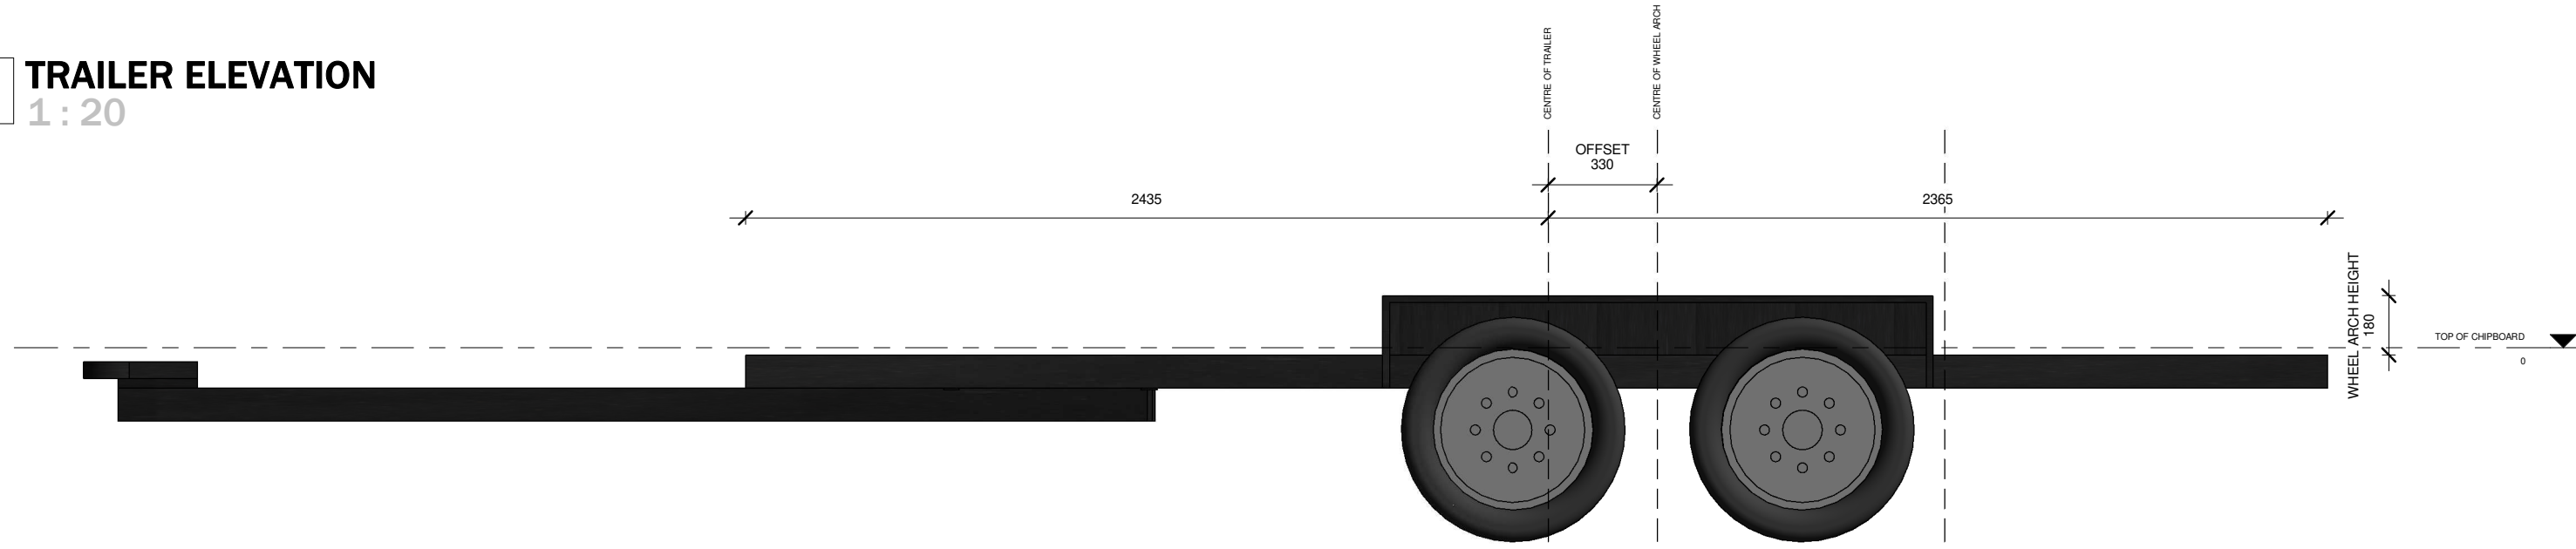


THE TINY TRAVELLER

DRAWING TITLE			SCALE	SHEET
TRAILER			1 : 20	A11
DRAWN BY	CHECKED BY	PROJECT N°	DATE	
FDLS		TheTinyTraveller	09-11-2020	



1 ELECTRICAL PLAN
1 : 20

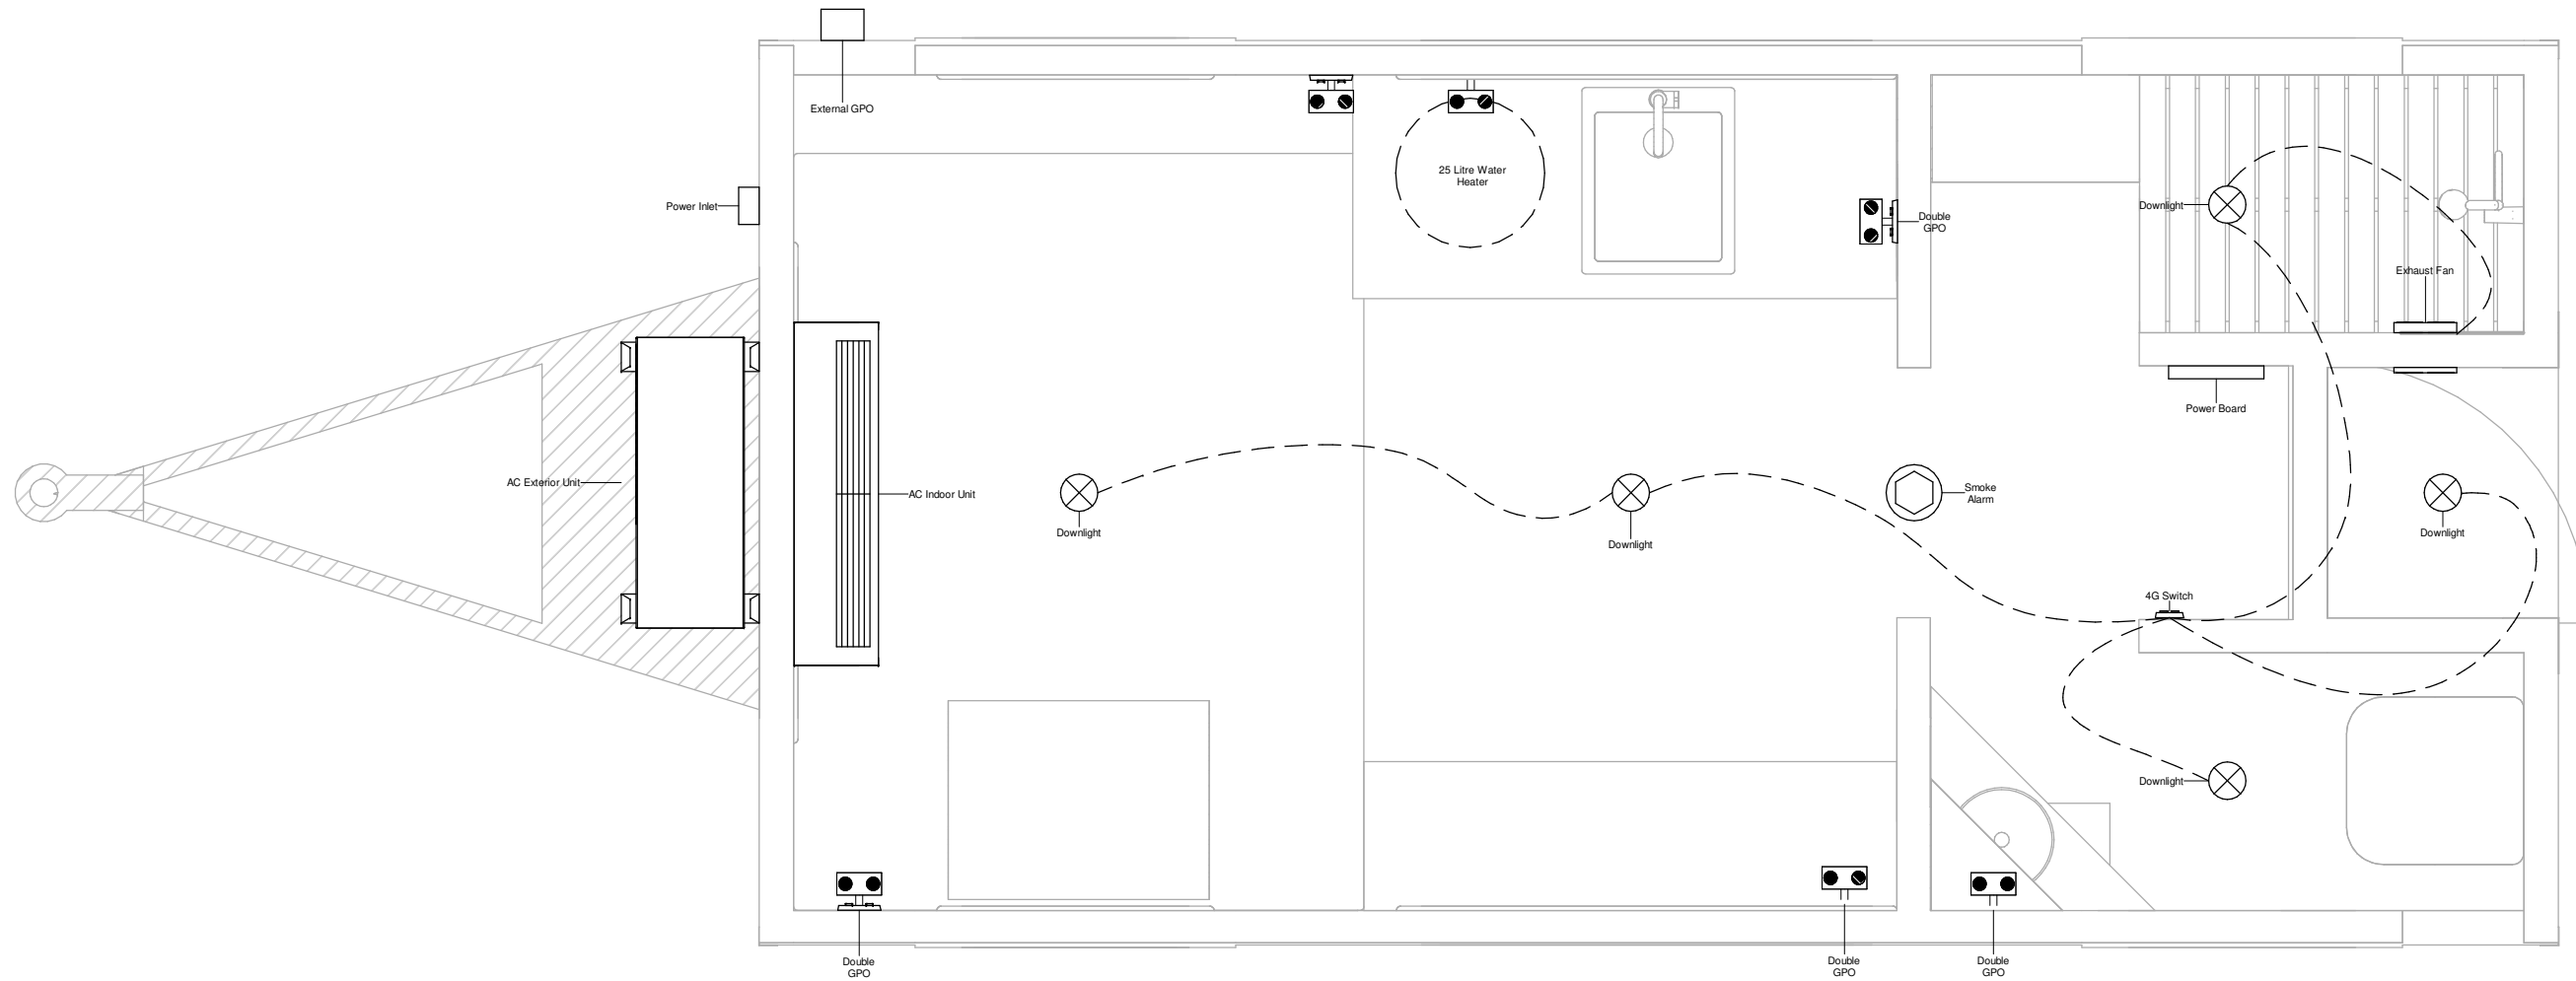

THE TINY TRAVELLER

DRAWING TITLE			SCALE	SHEET
ELECTRICAL PLAN			1 : 20	A12
DRAWN BY	CHECKED BY	PROJECT N°	DATE	
FDLS		TheTinyTraveller	09-11-2020	



Model:	The Tiny Traveller
Trailer:	
Type	4.8m x 2.4m 3500kg ATM Twin-Axle trailer
Vin no	
Frame:	
Floor	Red Tongue structural flooring
Walls	MPG10 - 70 x 35
Lintels	MPG10 - 90 x 45
Bracing	6mm OSB
Loft Frame	N/A
Loft sub floor	N/A
Rafters	MPG10 - 90 x 45
Roof battens	MPG10 - 70 X 35
Lock-up:	
Vapour permeable wall wrap	Bradford enviroseal proctor wrap
Under roof insulation and sarking	Spaceblanket R1. 8
Windows	Aluminium package single glazed - Black & White
Entry door	Aluminium 620 x 2040 single glazed - Black
External cladding A	Colorbond corrugated vertical profile - Monument
External cladding B	Weathertex Selflok 150 smooth - shale grey
External cladding finishes	Dulux weather shield - shale gray
Roof sheets	Colorbond corrugated Monument
Flashings	Colorbond steel BMT 0.42 Monument
Gutter and downpipes	N/A
Fix:	
Insulation walls	R2 wall batts
InSulation ceiling	R2 ceiling batts
Internal wall lining main	Easycraft wall panel
Internal ceiling	Easycraft wall panel
Internal wall lining bathroom	Aquapanel
Internal floors main	Engineered timber flooring
Internal floors bathroom shower	Stainless steel pan and Australian hardwood floor panel
Internal doors	N/A
Skirting	42x19mm Australian hardwood

Cabinetry:	
Kitchen	Melamine carcass Classic White sheen fronts
Benchtop	Australian hardwood
Bed	double drawer Classic white sheen front
Bed	Bed base lift up on gas struts for under storage
TV bed box	TV hidden inside electric lift mechanism
TV bed box benchtop	Australian hardwood
Bathroom Vanity corner cabinet	Melamine carcass Classic White sheen fronts
Bathroom benchtop	Australian hardwood
Desk	Melamine carcass Classic White sheen fronts
Desk benchtop	Australian hardwood
Handles	TBC
Plumbing items:	
Hot water service	Rheem stellar 25L Electric
Bathroom basin	round above benchtop
Bathroom tap	chrome
Shower mixer	Nebia
Shower head	Nebia
Kitchen sink	top mount stainless single bowl
Sink tap	chrome
Shower screen	curtain
Electrical Items:	
Switchboard	1 main switch 5 breakers
AC unit	Mitsubishi 2.5KW
Bathroom exhaust fan	100mm
Double power point (internal)	8
External powerpoint	1
Light fixtures (internal)	4
External light fixtures	1
light switches	4
Smoke alarm	1
TV antenna	1
Data in	0
Data out	0
Internal paint and timber finishes	
Walls	Dulux wash and wear natural white
Ceiling	Dulux professional ceiling flat white
Timber benchtops	Fiddes hard wax oil

THE TINY TRAVELLER

DRAWING TITLE			SCALE	SHEET
SPECIFICATIONS				A13
DRAWN BY	CHECKED BY	PROJECT N°	DATE	
FDLS		TheTinyTraveller	09-11-2020	

