



1

EXTV 1

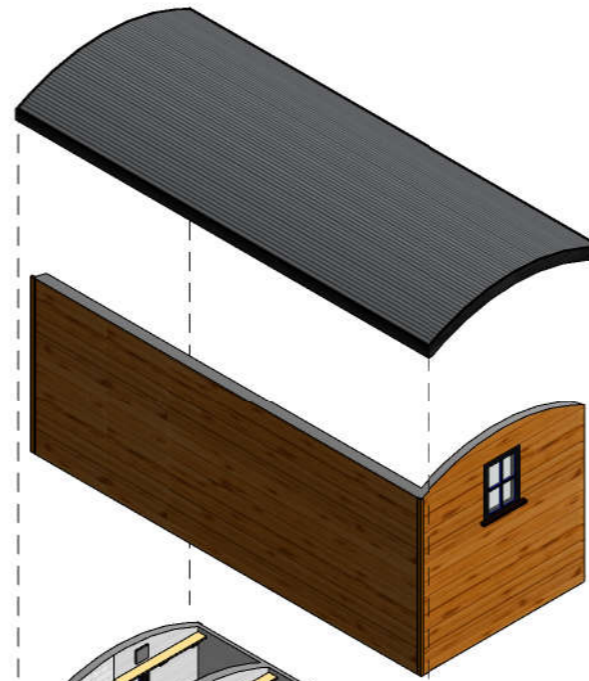

COLORBOND COORUGATED ROOF

WEATHERBOARD CLADDING

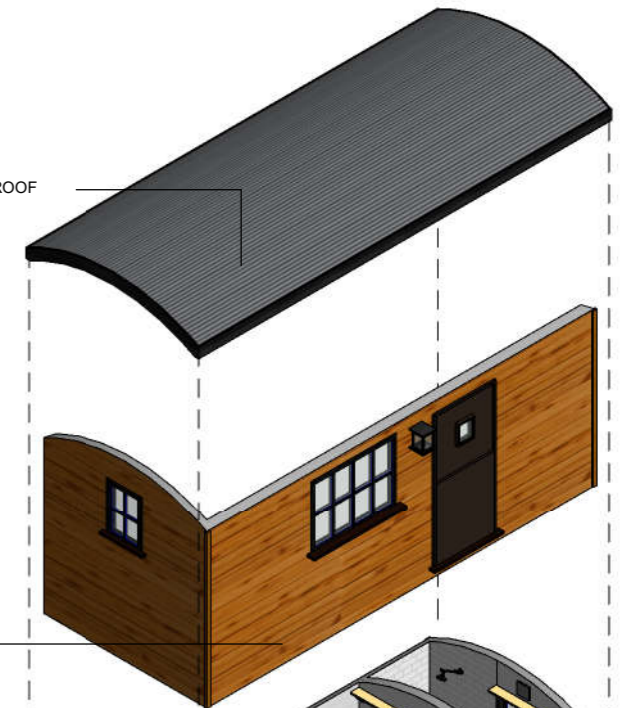

KITCHENETTE




FOLD-OUT DESK

CUSTOM DESIGNED BED FRAME




2

EXTV 2

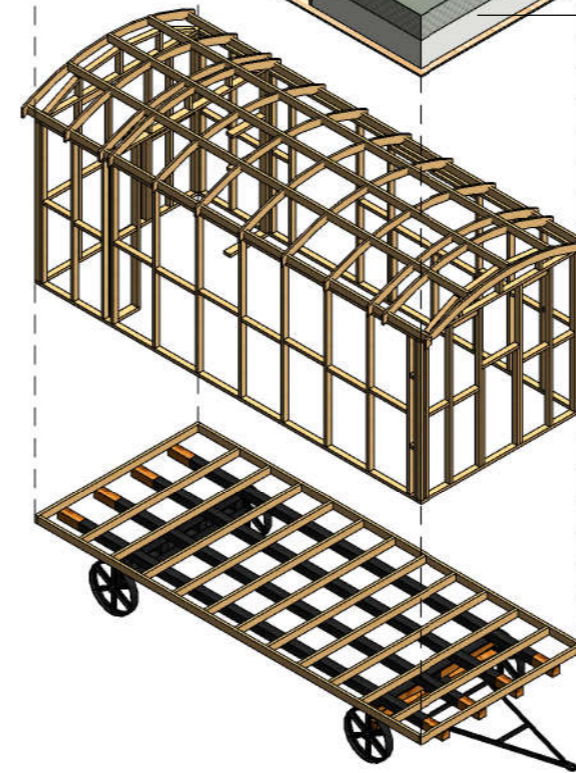

TIMBER FRAME

CUSTOM DESIGNED 2-AXLE TRAILER

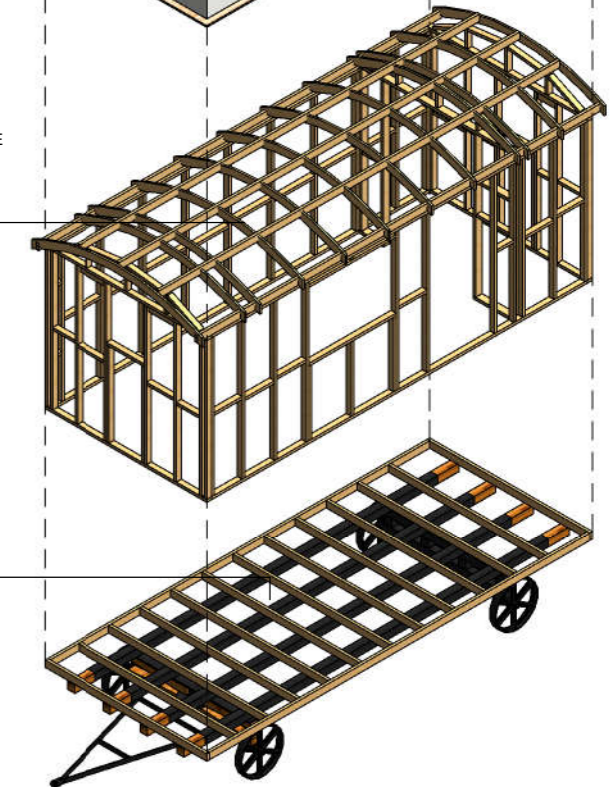

SCALE

HANGAN SHEPHERD HUT - 5.4M

DRAWING TITLE

SHEPHERD HUT VIEWS

PROJECT N°

Project Number

DATE

28/02/2020 14:05:21

SHEET

A001

**HANGAN**  
TINY HOMES



**1** INTV 1




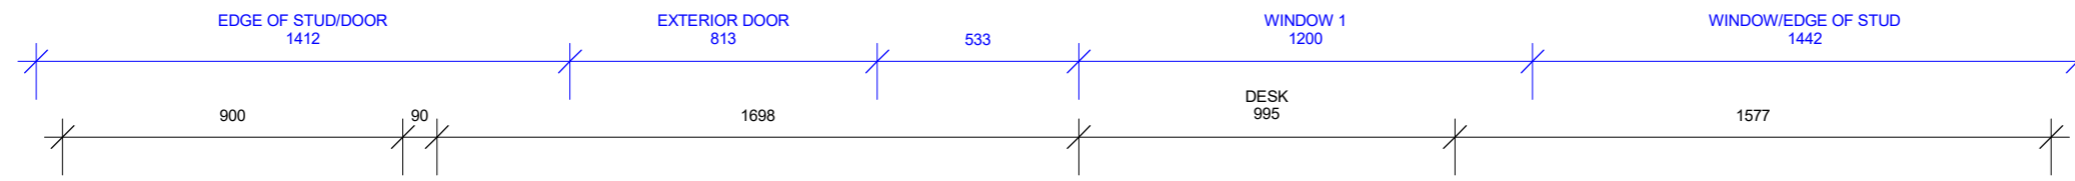
**2** INTV 2

SCALE	<b>HANGAN SHEPHERD HUT - 5.4M</b>	DRAWING TITLE	PROJECT N°	DATE	SHEET	
		TH INTERIOR VIEWS	Project Number	28/02/2020 14:05:24	A002	




**1** TOP HEIGHT  
1 : 20

SCALE	<b>HANGAN SHEPHERD HUT - 5.4M</b>	DRAWING TITLE	PROJECT N°	DATE	SHEET	
1 : 20		TOP VIEW	Project Number	28/02/2020 14:05:25	A004	



**1 FINISHED FLOOR LEVEL**  
1 : 20

SCALE	<b>HANGAN SHEPHERD HUT - 5.4M</b>	DRAWING TITLE	PROJECT N°	DATE	SHEET	
1 : 20		FIRST LEVEL	Project Number	28/02/2020 14:05:27	A005	

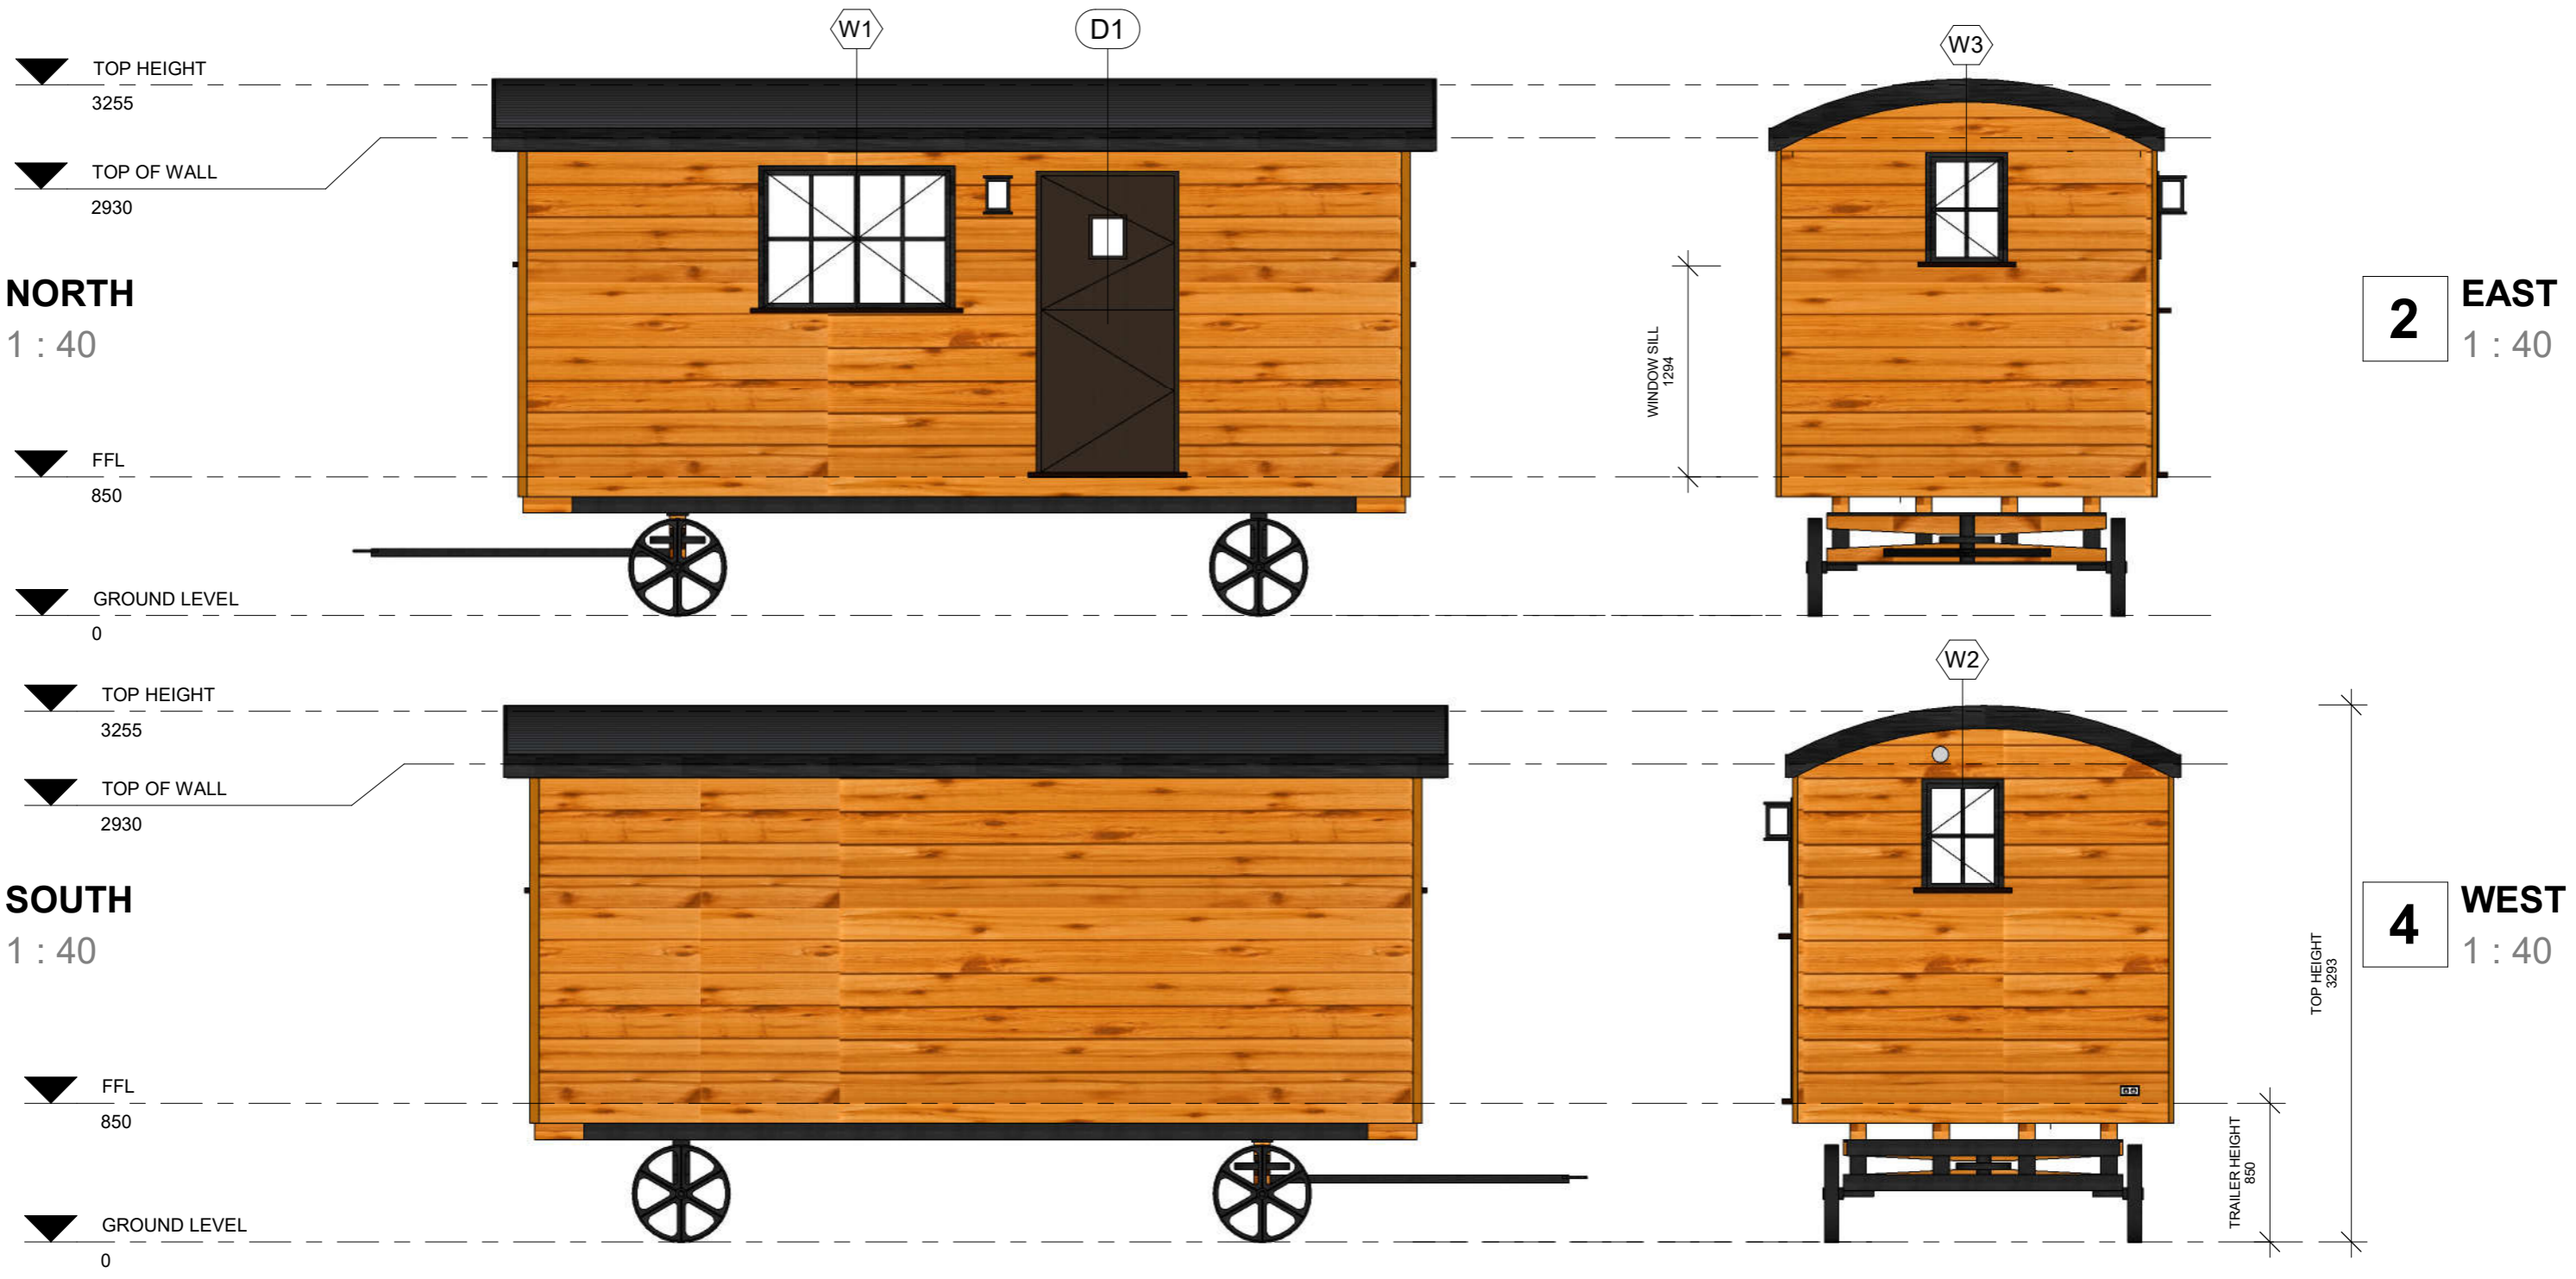


**WINDOW SCHEDULE**


MARK	WINDOW TYPE	FRAME MATERIALS	FRAME COLOUR	HEIGHT	WIDTH	SILL HEIGHT	INTERNAL ARCHITRAVE	EXTERNAL ARCHITRAVE	REVEAL WIDTH
W1	DOUBLE HINGED	TIMBER	BLACK	900	1200	1013	70	50	
W2	SINGLE HINGED	TIMBER	BLACK	700	500	1294	70	50	
W3	SINGLE HINGED	TIMBER	BLACK	700	500	1294	70	50	

**DOOR SCHEDULE**

MARK	TYPE	DESCRIPTION	MATERIAL	COLOUR	HEIGHT	WIDTH
D1	HINGED	2 OPENINGS W/ FIXED WINDOW	TIMBER	BLACK	1850	915
D2	CAVITY SLIDER		TIMBER	BLACK	1966	660

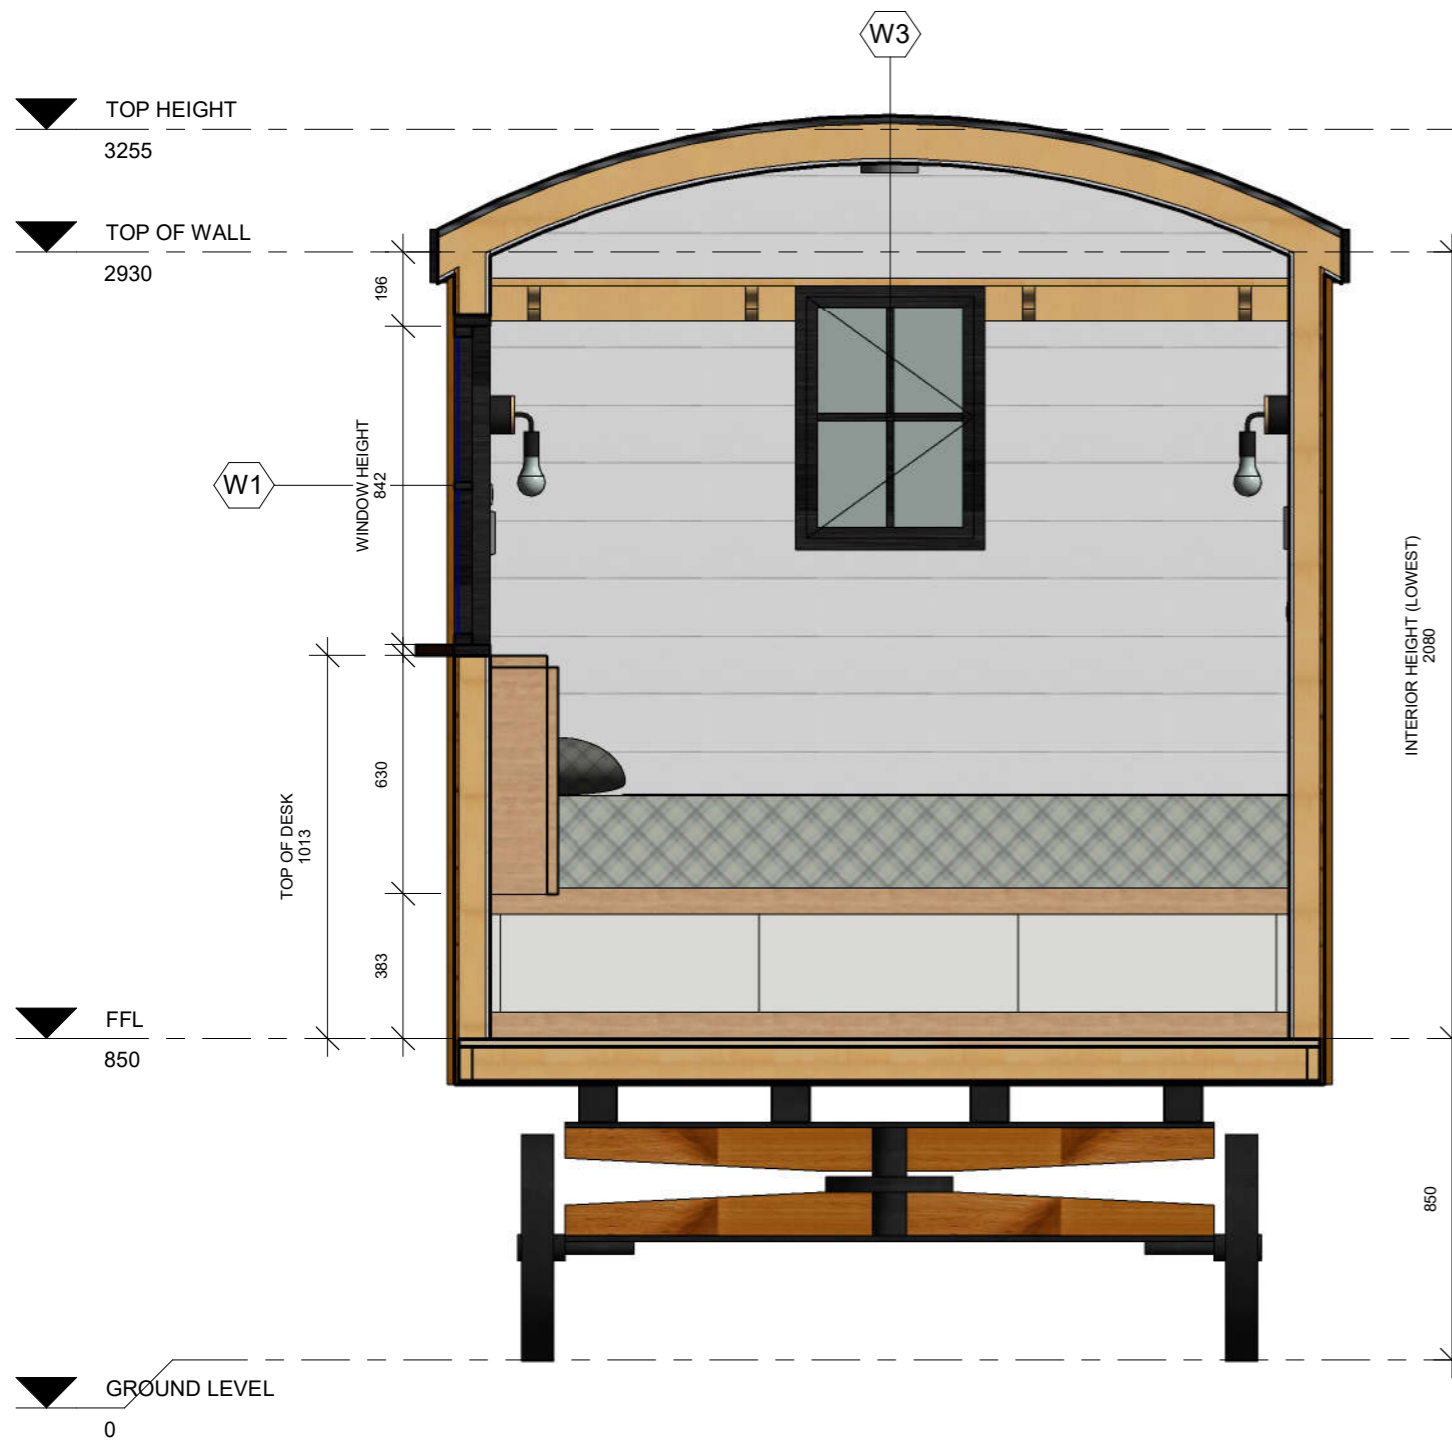


**A** SECTION A  
1 : 20

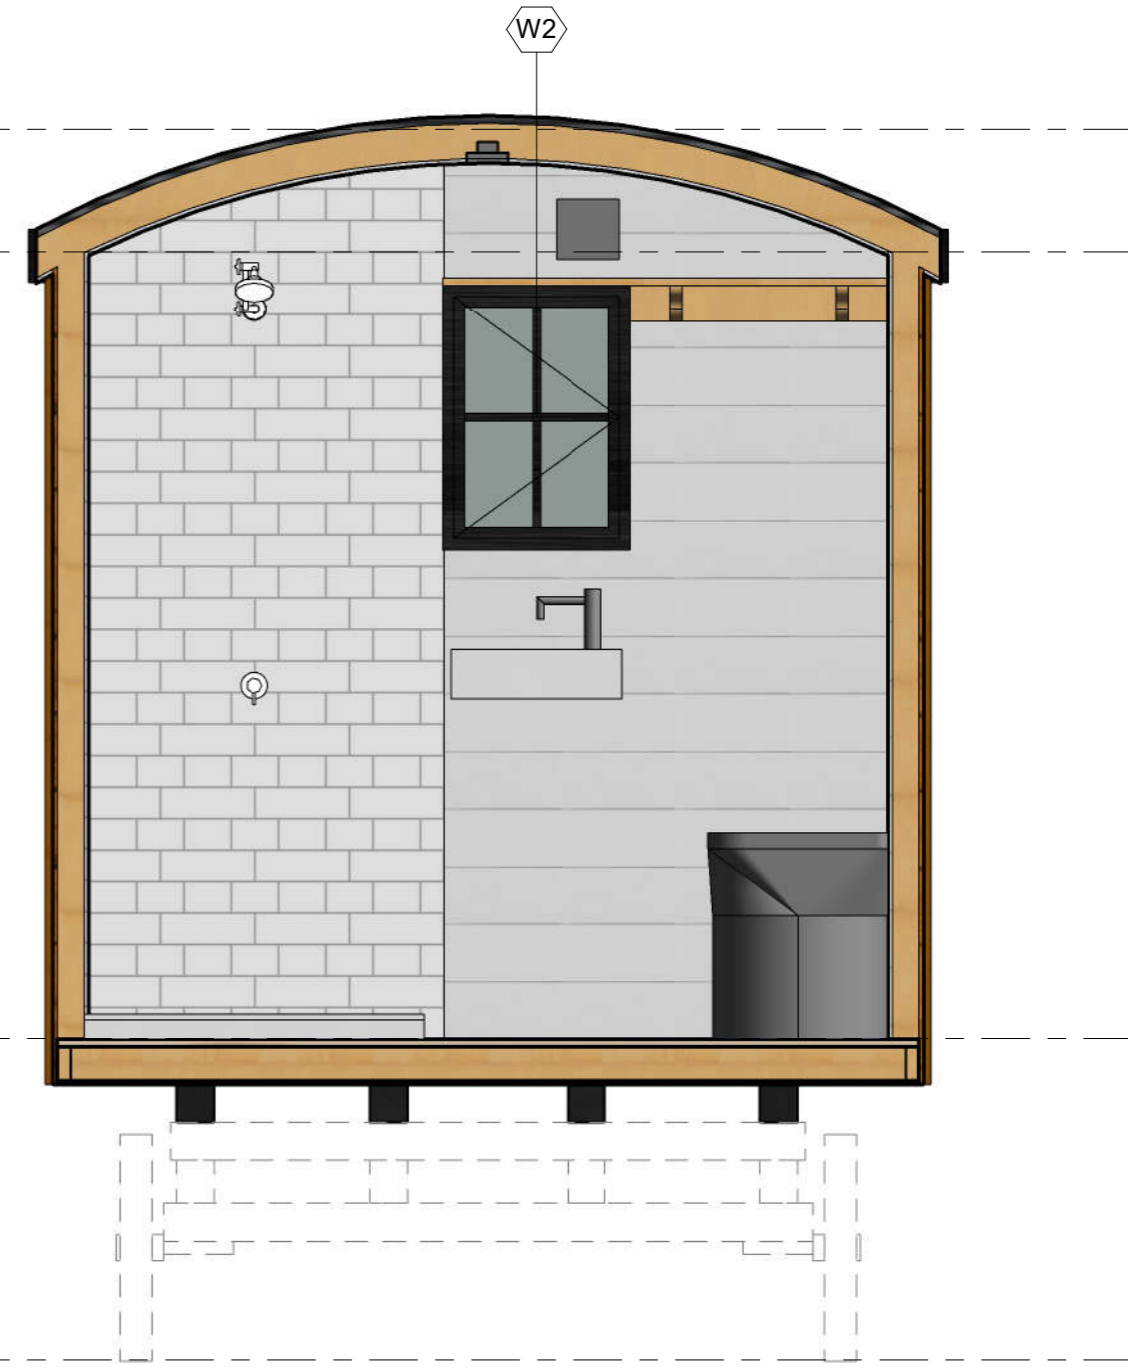

**B** SECTION B  
1 : 20

SCALE	<b>HANGAN SHEPHERD HUT - 5.4M</b>	DRAWING TITLE	PROJECT N°	DATE	SHEET	
1 : 20		SECTION A & B	Project Number	28/02/2020 14:05:31	A007	

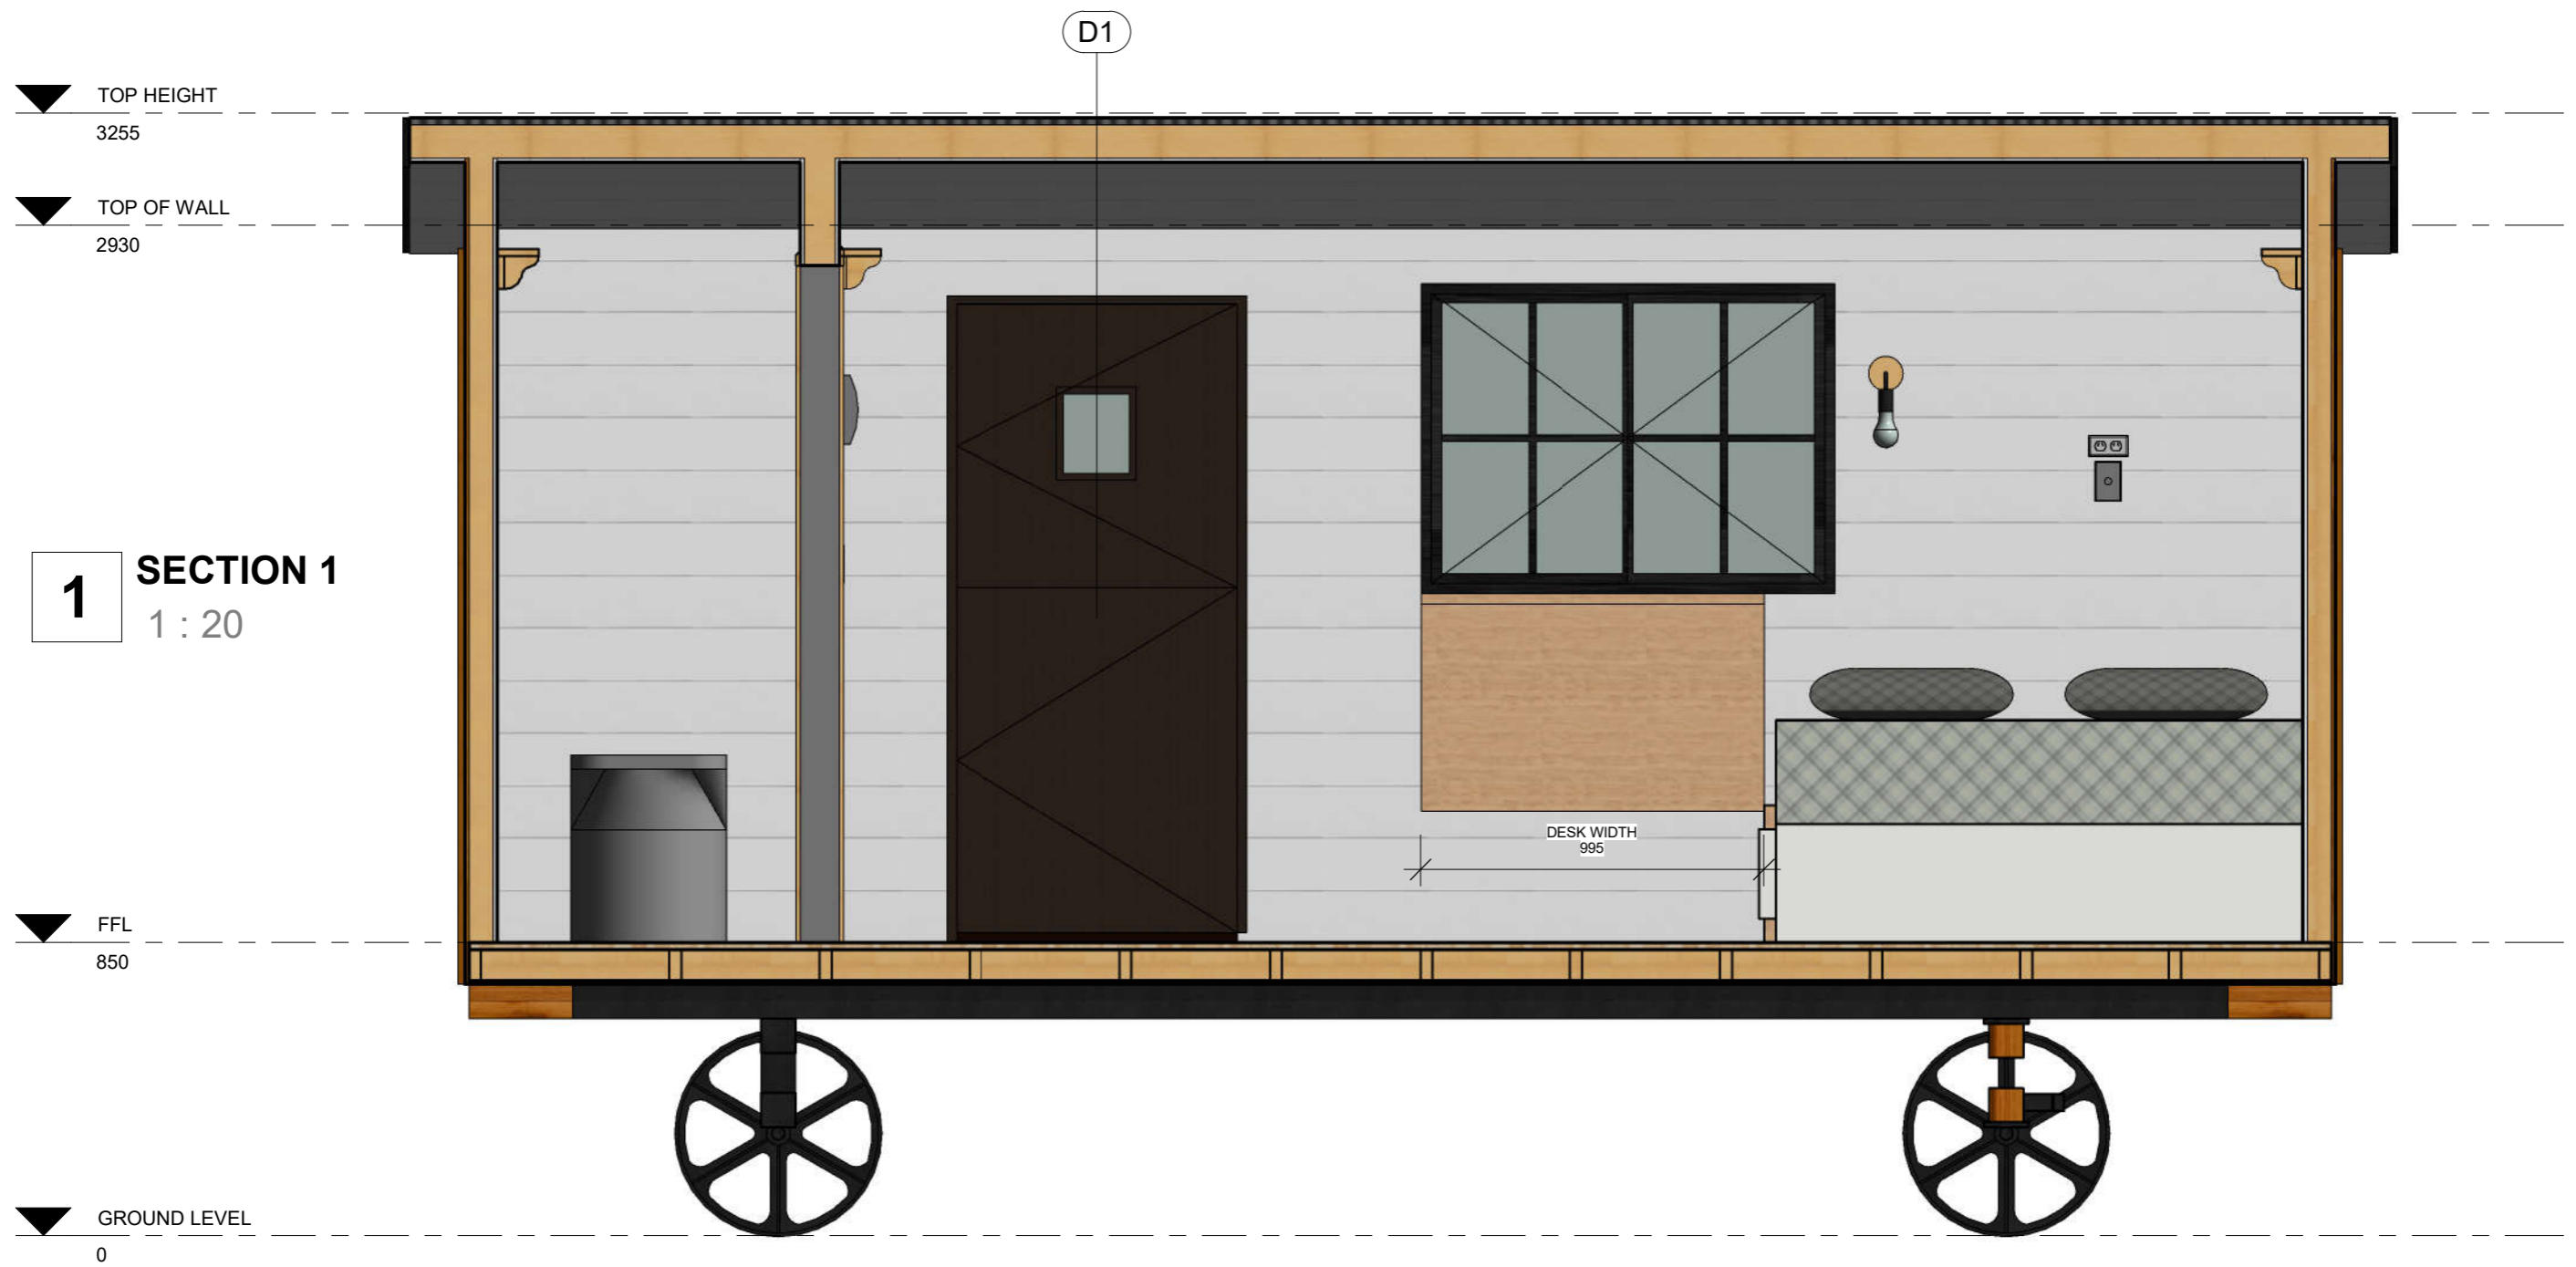

SCALE	<b>HANGAN SHEPHERD HUT - 5.4M</b>	DRAWING TITLE	PROJECT N°	DATE	SHEET	
1 : 20		SECTION 1	Project Number	28/02/2020 14:05:33	A008	

▼ TOP HEIGHT  
3255

▼ TOP OF WALL  
2930

**2** SECTION 2  
1 : 20

▼ FFL  
850

▼ GROUND LEVEL  
0



SCALE

1 : 20

**HANGAN SHEPHERD HUT - 5.4M**

DRAWING TITLE

SECTION 2

PROJECT N°

Project Number


DATE

28/02/2020 14:05:34

SHEET

A009

**HANGAN**  
TINY HOMES

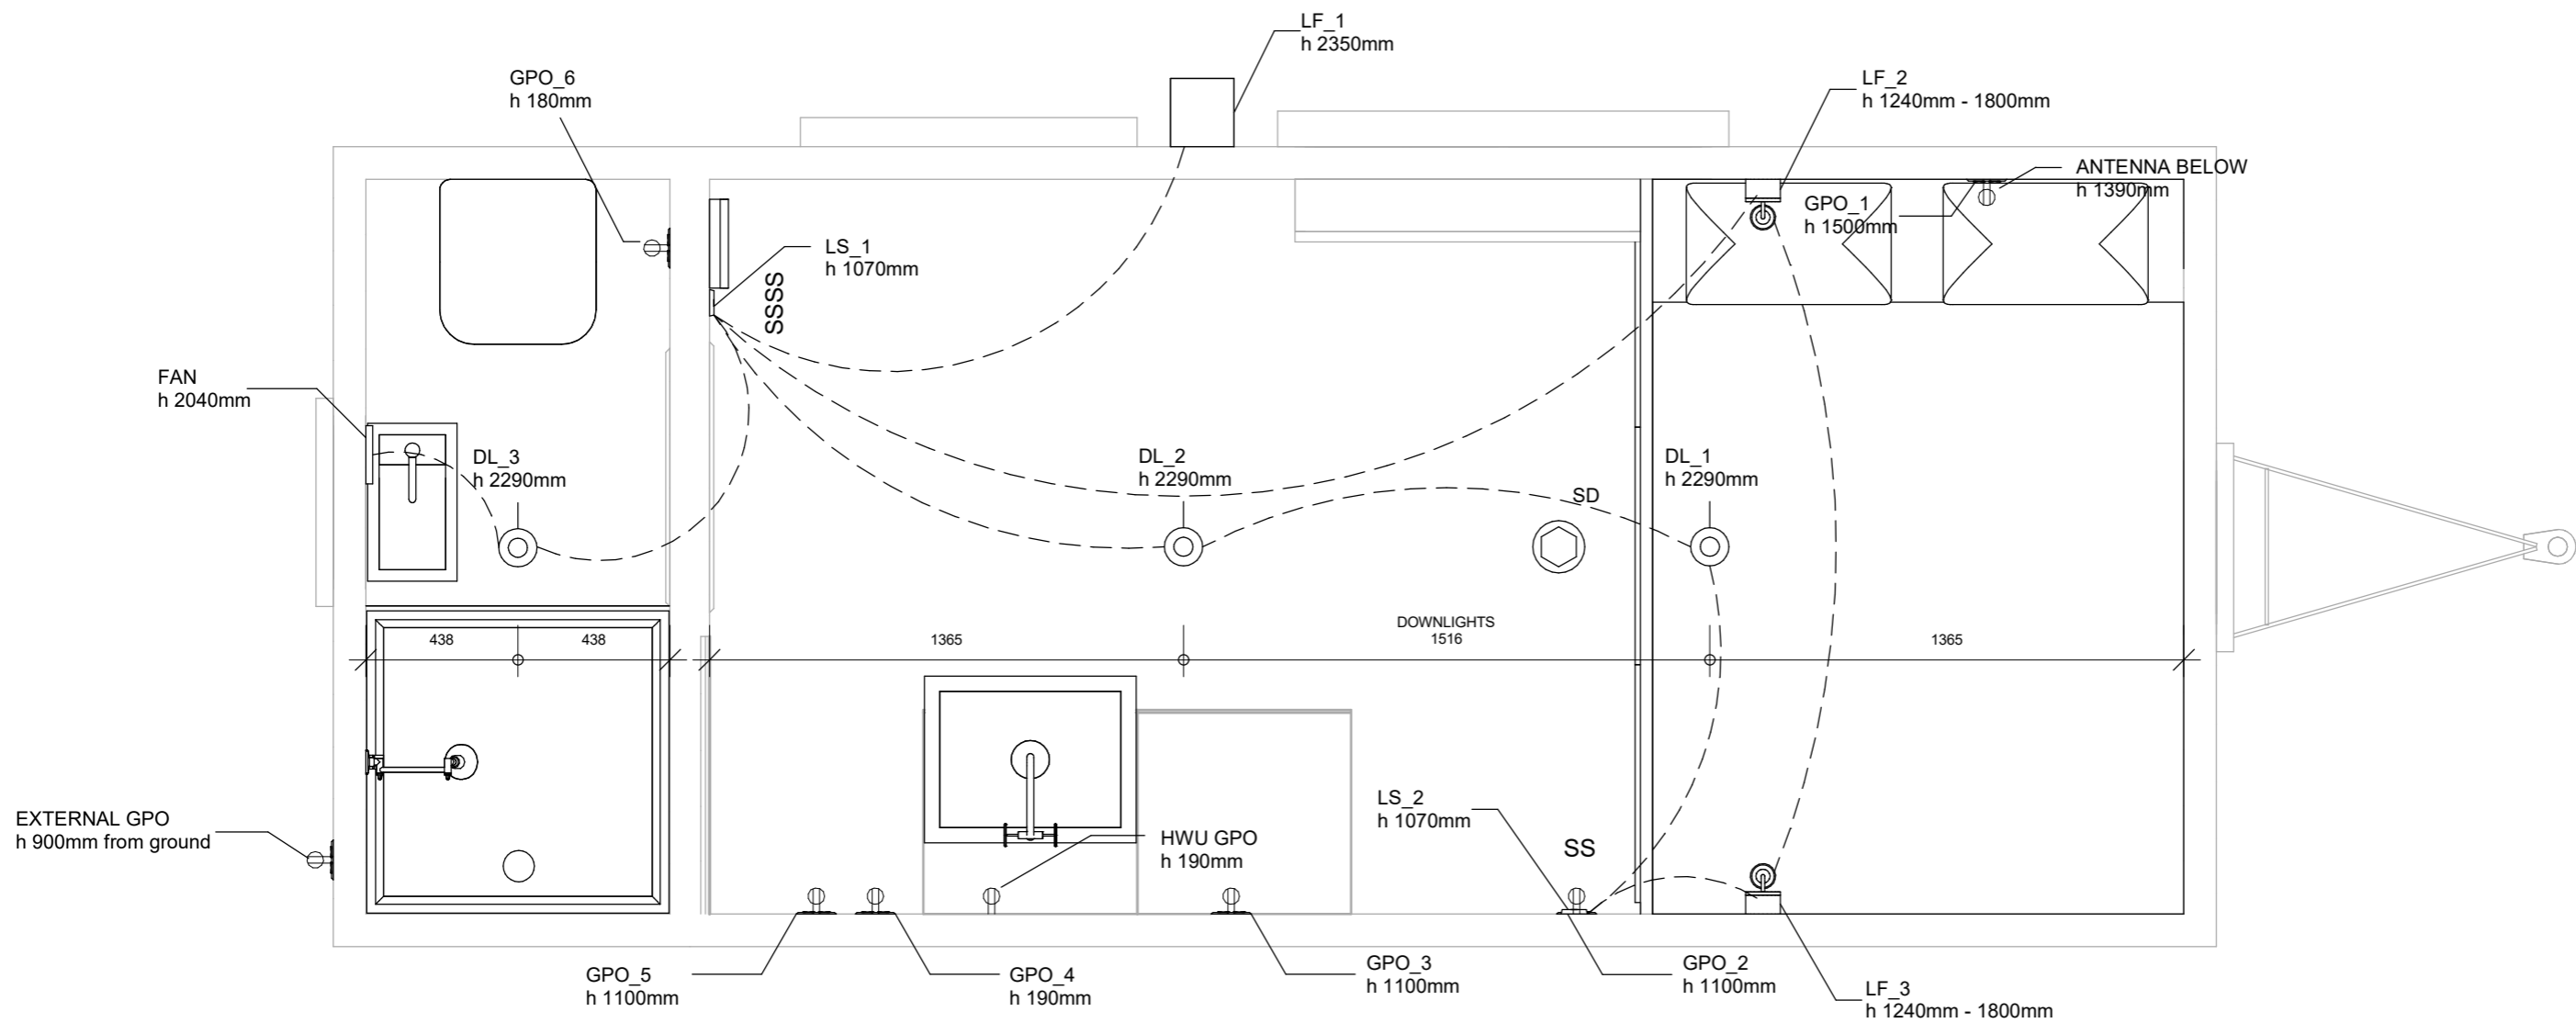

# 1 ELECTRICAL PLAN


1 : 20

ELECTRICAL FIXTURES SCHEDULE		
Mark	Description	Elevation from Level
GPO_1	DOUBLE POWER POINT (WHITE)	1410
GPO_2	DOUBLE POWER POINT (WHITE)	1100
GPO_3	DOUBLE POWER POINT (WHITE)	1100
GPO_4	DOUBLE POWER POINT (WHITE)	190
GPO_5	DOUBLE POWER POINT (WHITE)	1100
GPO_6	DOUBLE POWER POINT (WHITE)	180
GPO_7	WEATHERPROOF OUTDOOR DOUBLE POWER POINT (WHITE)	50
HWU GPO	DETA X6 White Double Power Point	190


ELECTRICAL EQUIPMENT SCHEDULE		
Mark	Description	Elevation from Level
EE_1	SWITCHBOARD	1055
EE_2	TV OUTLET	2130
EE_3	EXHAUST FAN	2944
SD_1	SMOKE ALARM	1843

LIGHTING FIXTURE SCHEDULE		
Mark	Description	Elevation from Level
LF_1	Wall Light Lantern	1734
LF_2	MEZZANINE WALL MOUNTED INTERIOR LIGHT	2500
LF_3	MEZZANINE WALL MOUNTED INTERIOR LIGHT	2500
LS_1	Switch Standard 2G Vert 10A 250V White	1640
LS_2	Switch Standard 2G Vert 10A 250V White	2143


**1 ISOMETRIC VIEW**

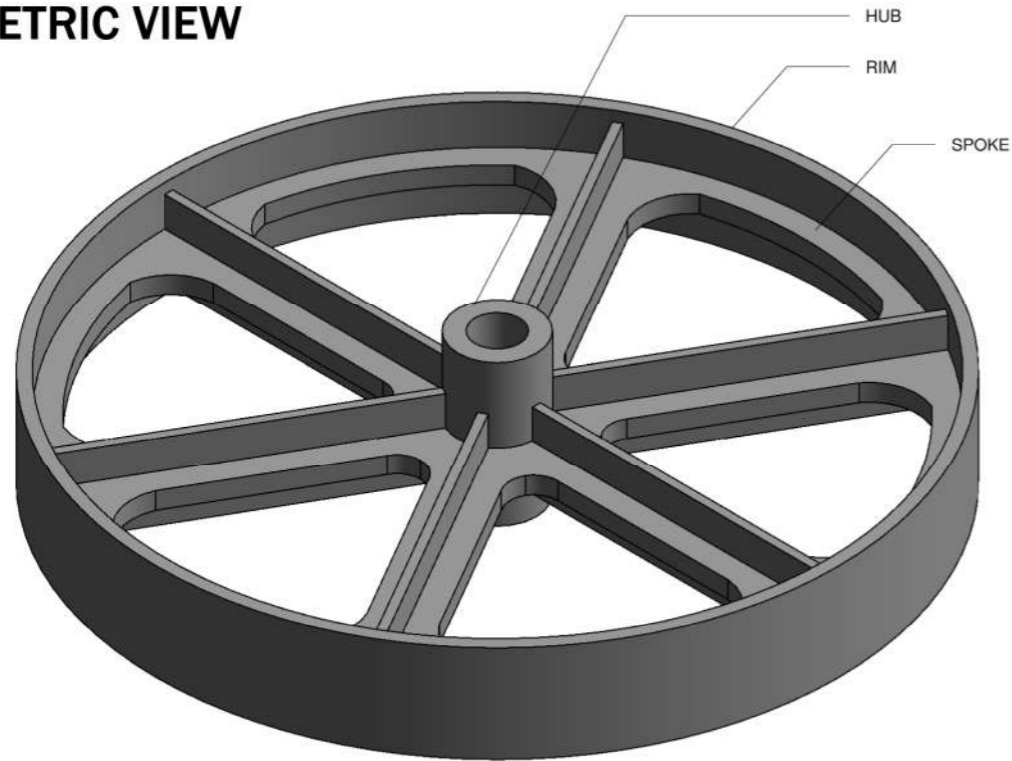


**2 PLAN VIEW**  
1:5

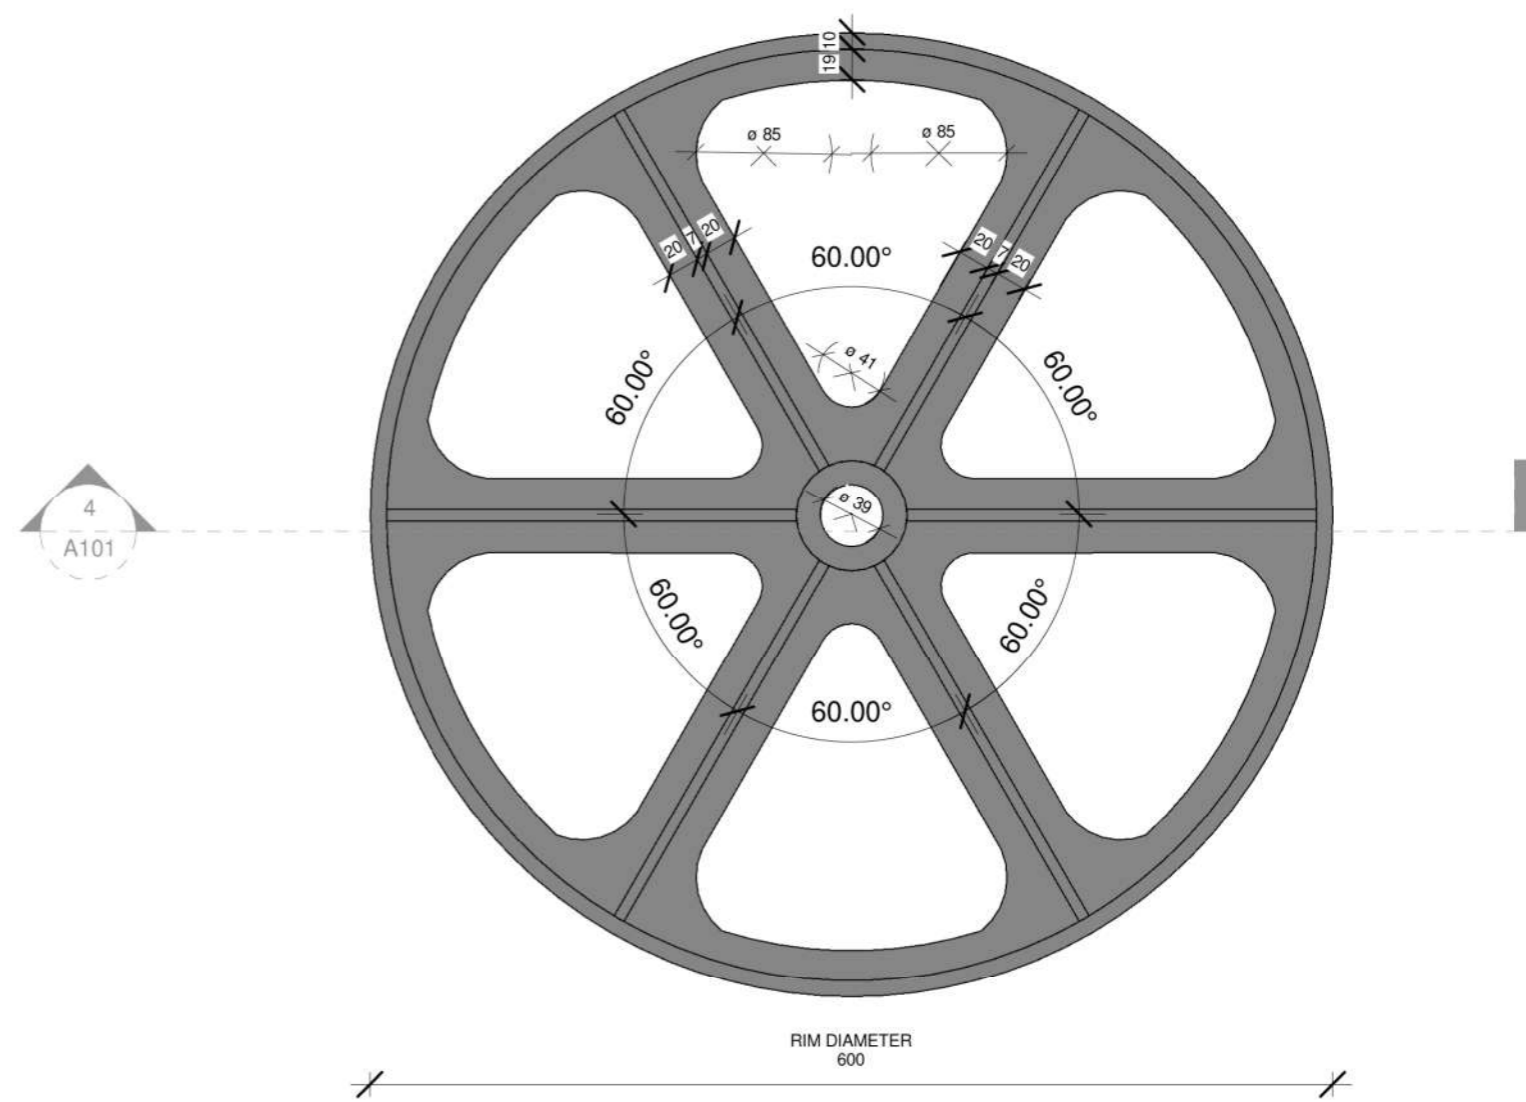


**3 ELEVATION**  
1:5

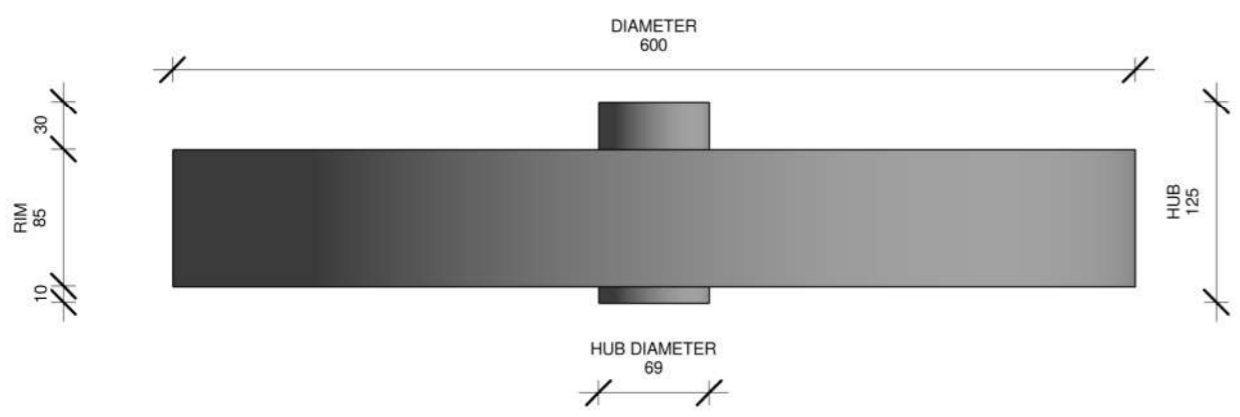

**4 SECTION**  
1:5

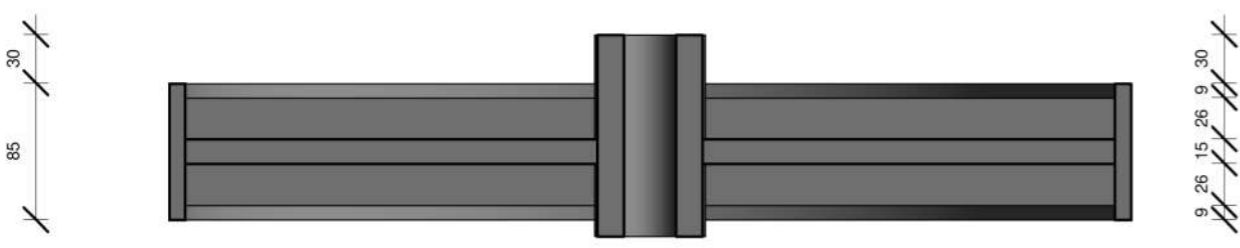

SCALE	<b>HANGAN SHEPHERD HUT - 5.4M</b>	DRAWING TITLE	PROJECT N°	DATE	SHEET	
		FABRICATION PLAN - WHEEL	Project Number	28/02/2020 14:05:36	A013	

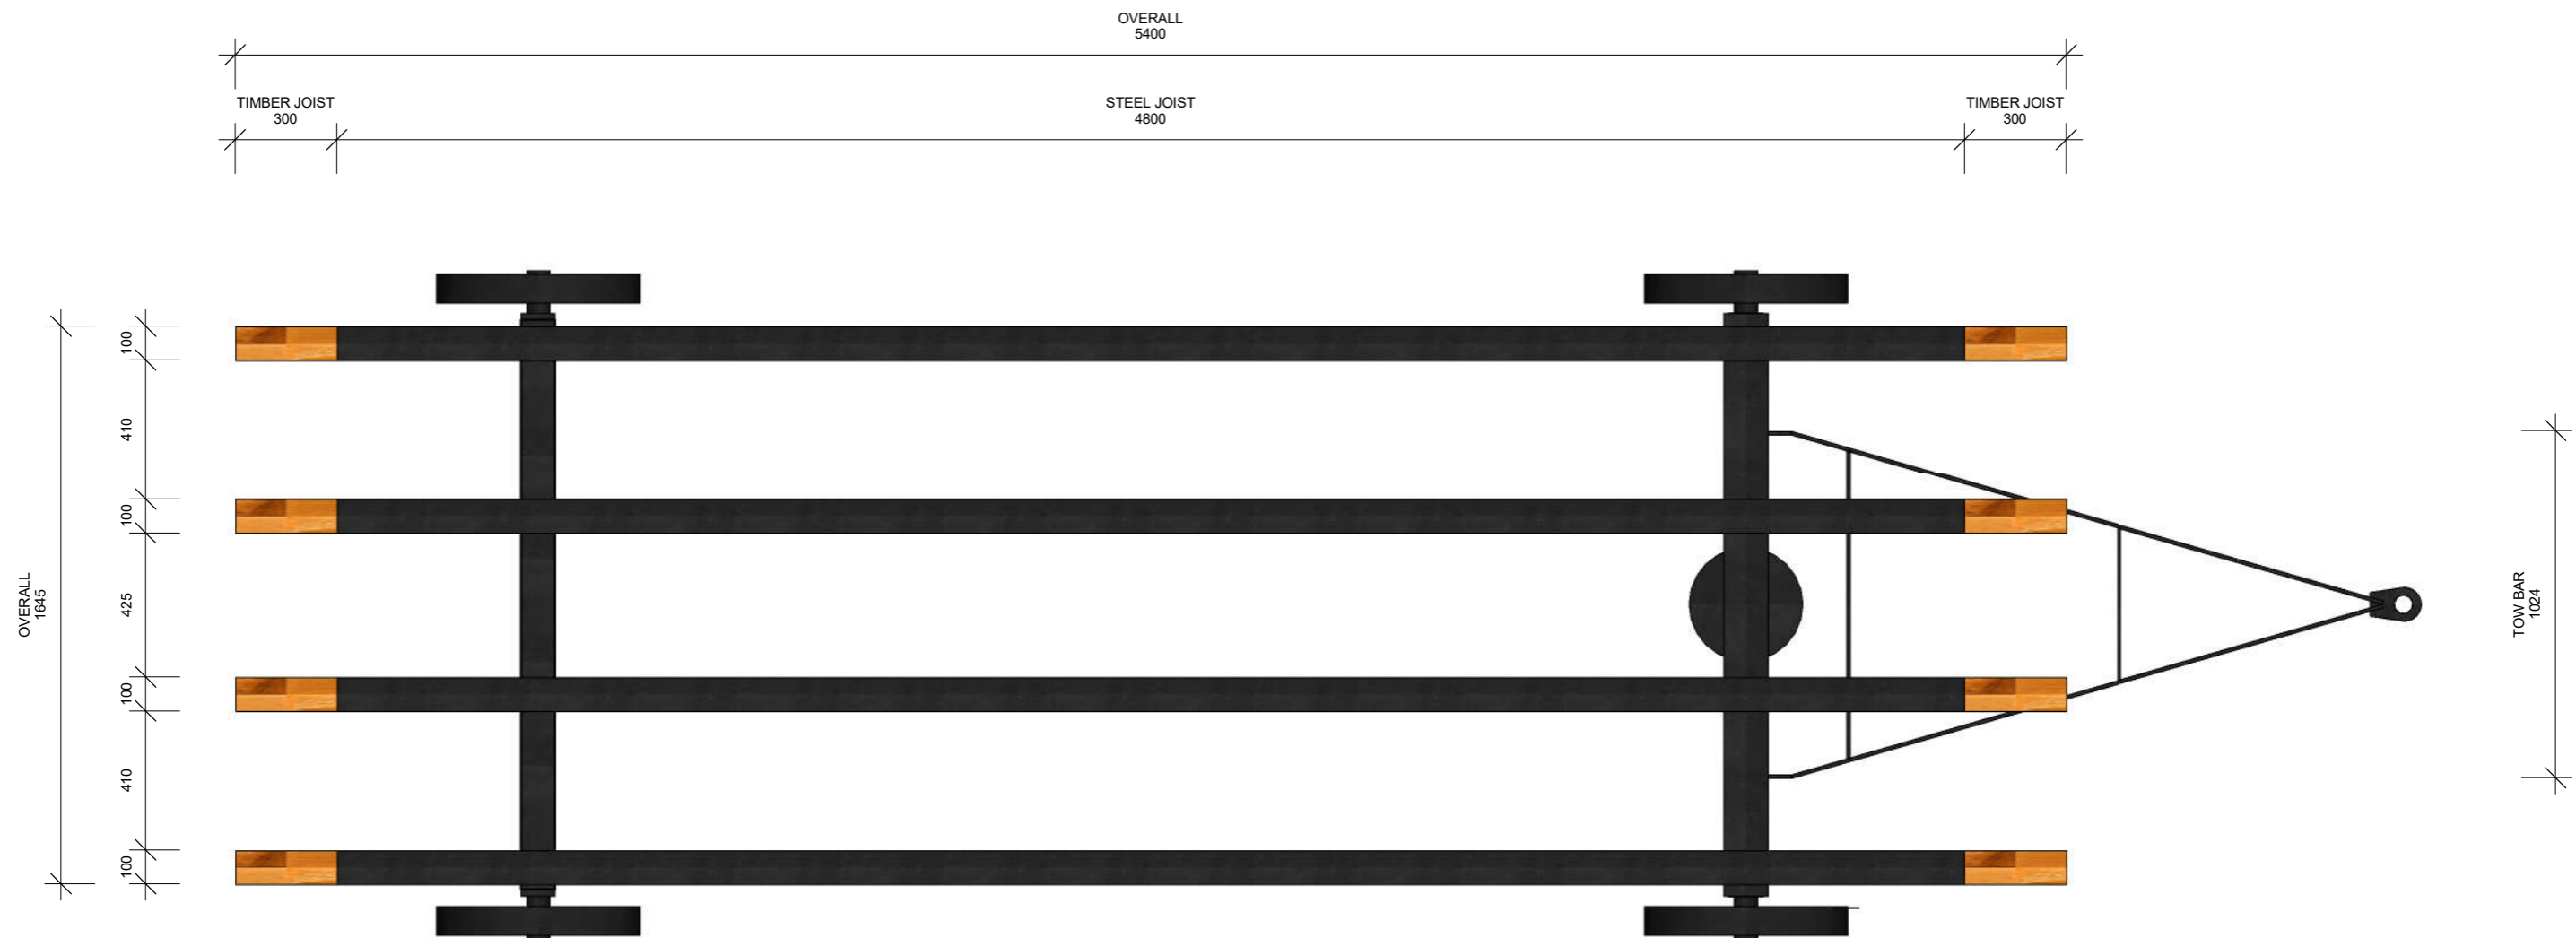


**1 TRAILER PLAN**  
1 : 20




**2 TRAILER ELEVATION**  
1 : 20

SCALE 1 : 20	<b>HANGAN SHEPHERD HUT - 5.4M</b>	DRAWING TITLE	PROJECT N°	DATE	SHEET	
		TRAILER PLAN	Project Number	28/02/2020 14:05:37	A015	




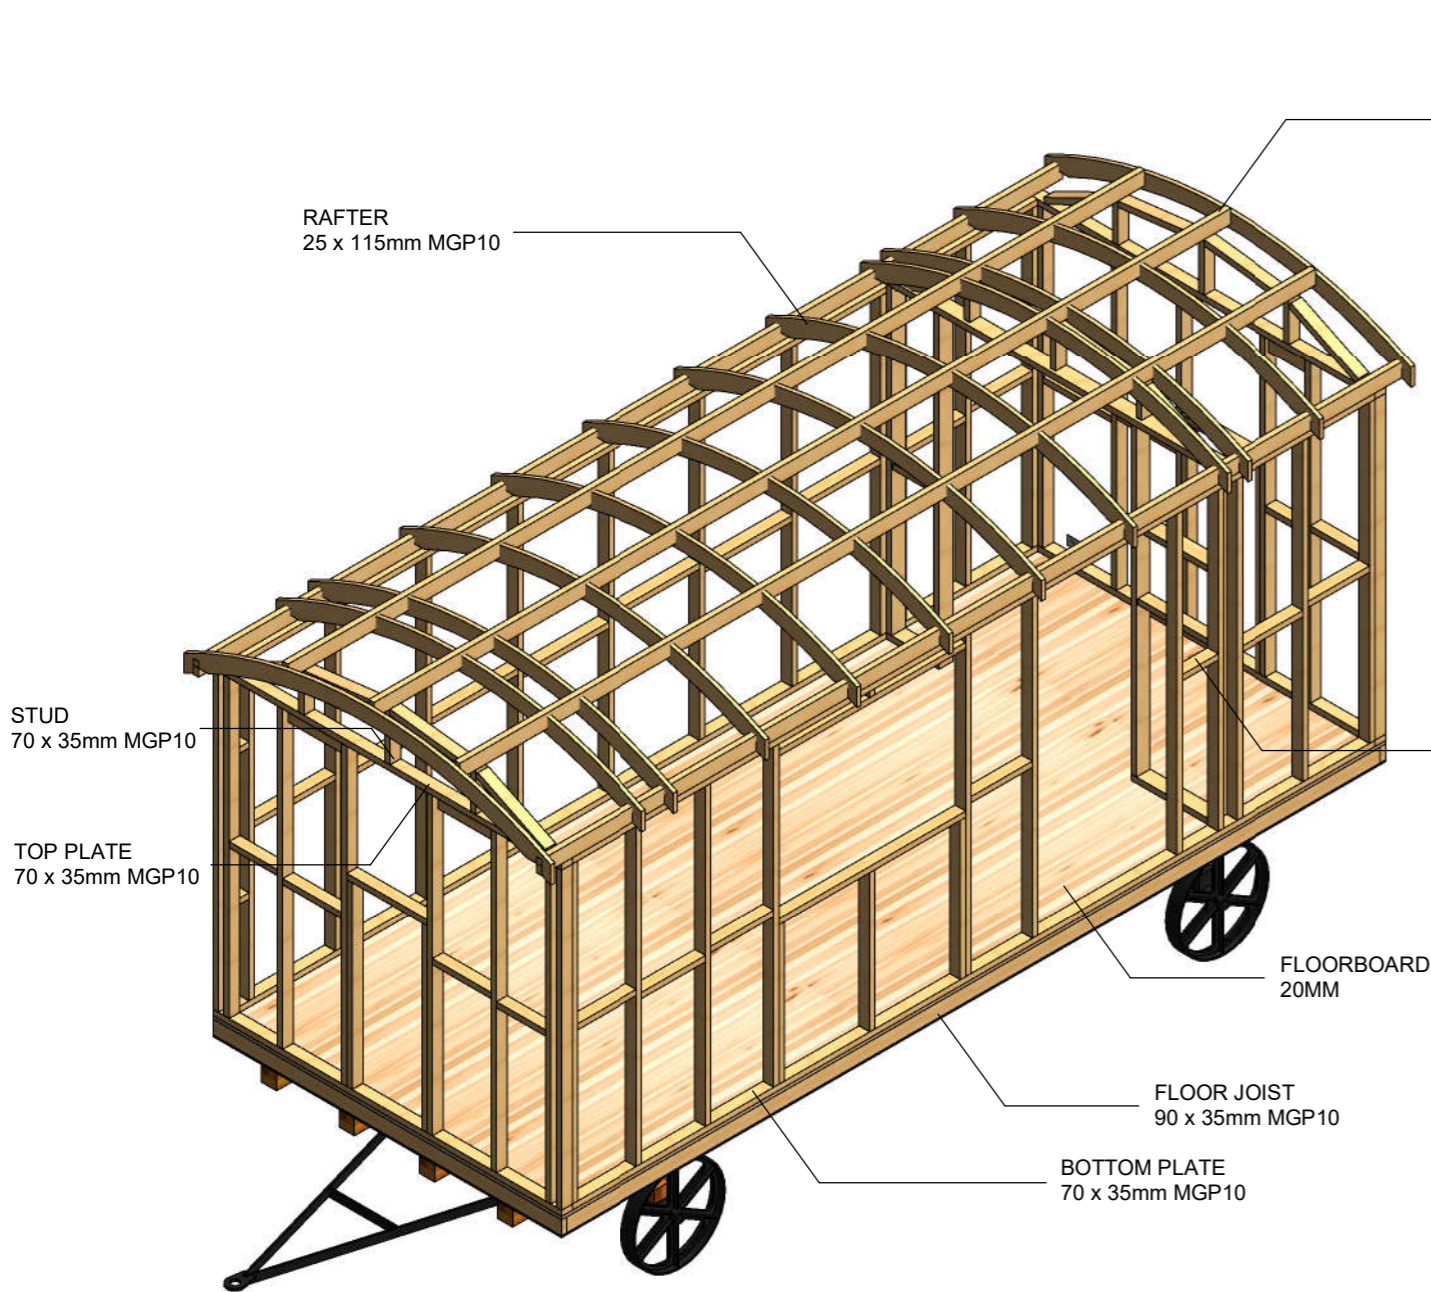


**1** FRAME ISO 1

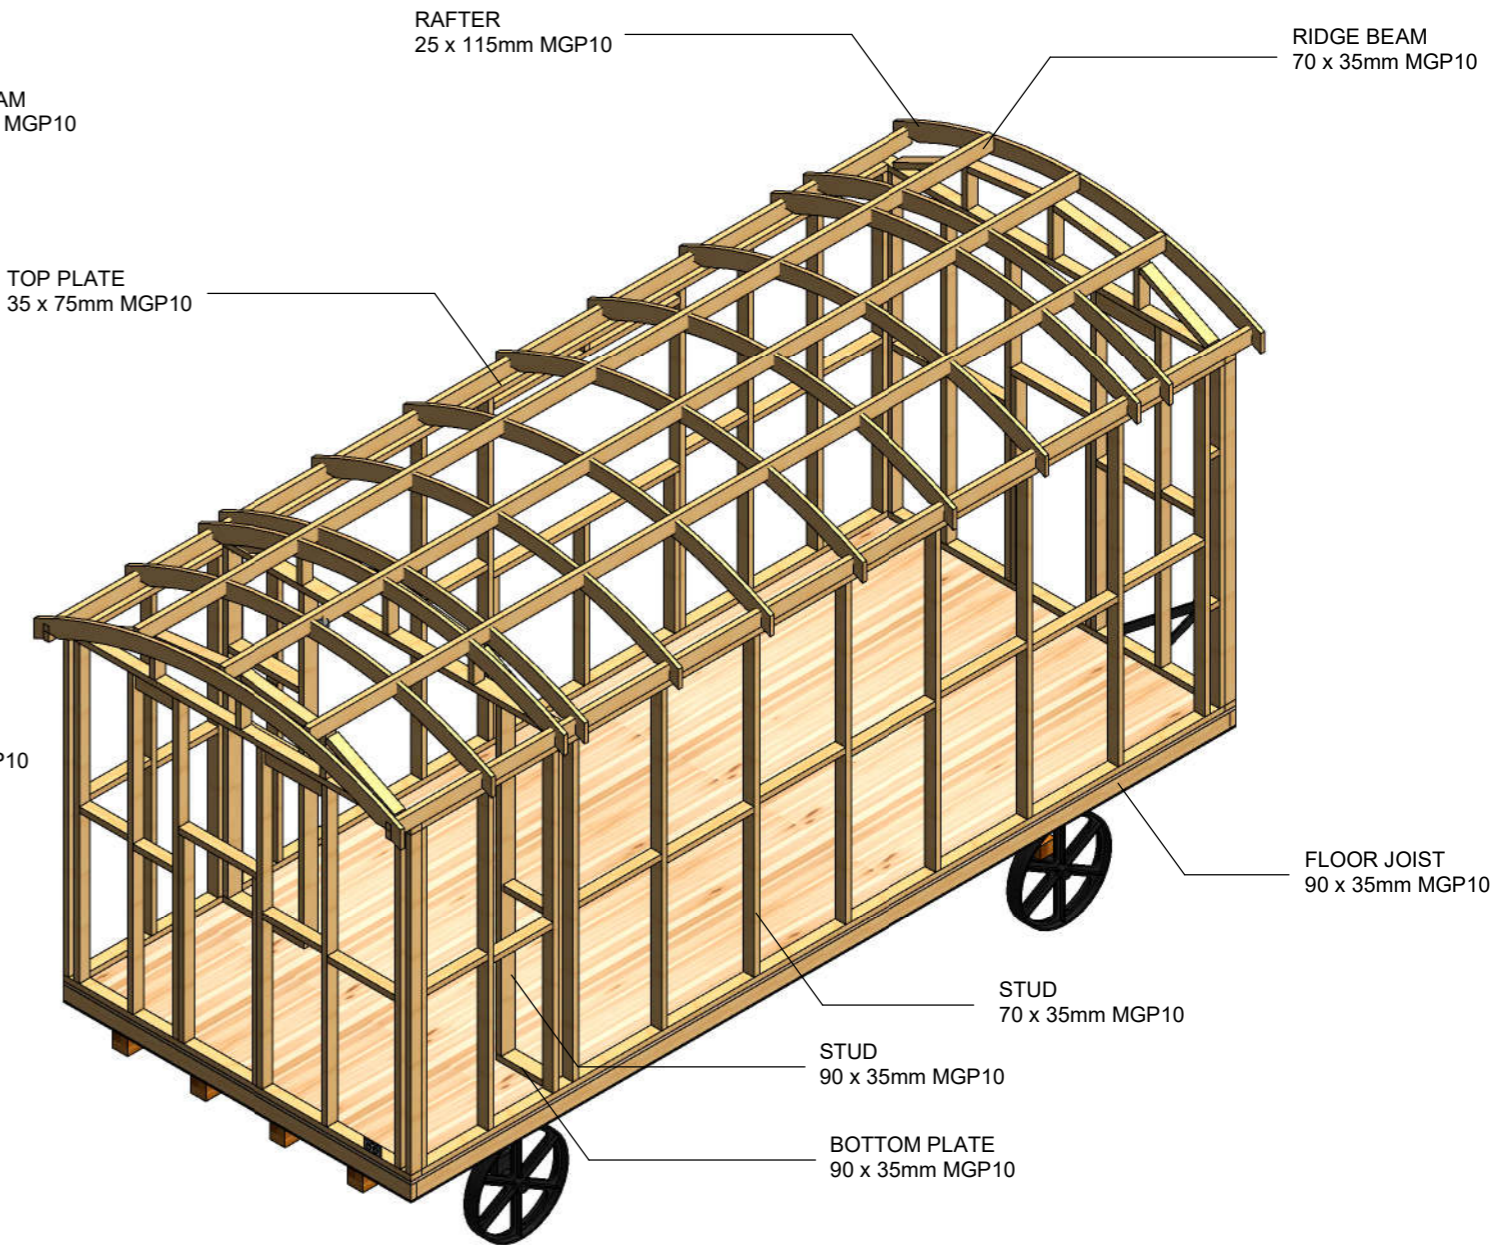


**2** FRAME ISO 2

SCALE	<b>HANGAN SHEPHERD HUT - 5.4M</b>	DRAWING TITLE	PROJECT N°	DATE	SHEET	
		FRAMING ISO	Project Number	28/02/2020 14:05:38	A016	

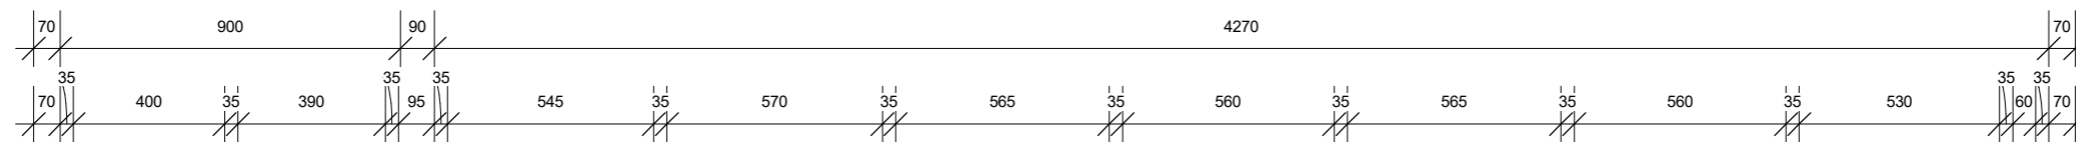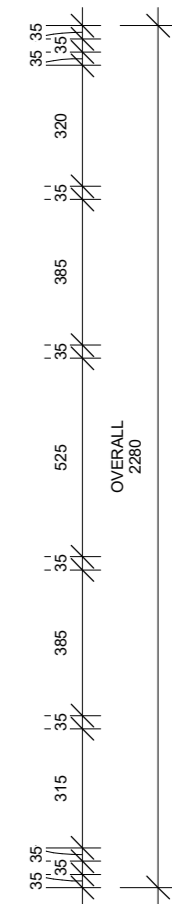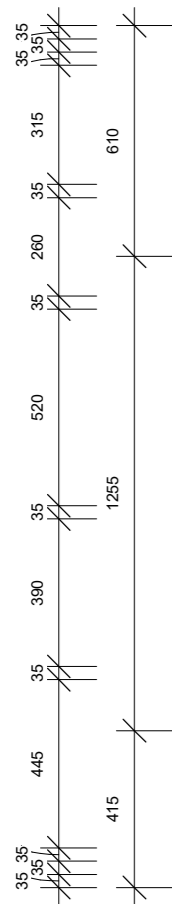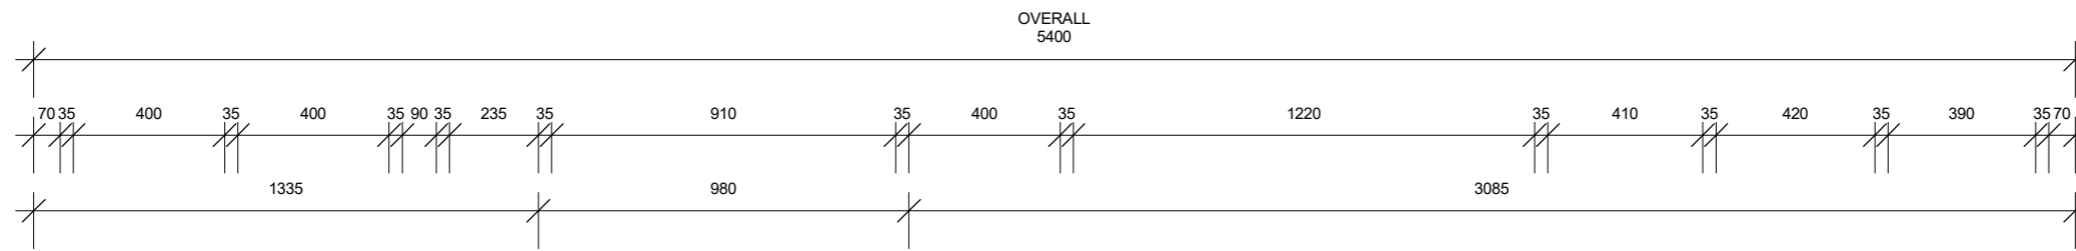


**1** FRAME PLAN  
1 : 20

SCALE	<b>HANGAN SHEPHERD HUT - 5.4M</b>	DRAWING TITLE	PROJECT N°	DATE	SHEET	
1 : 20		FRAME PLAN	Project Number	28/02/2020 14:05:38	A017	

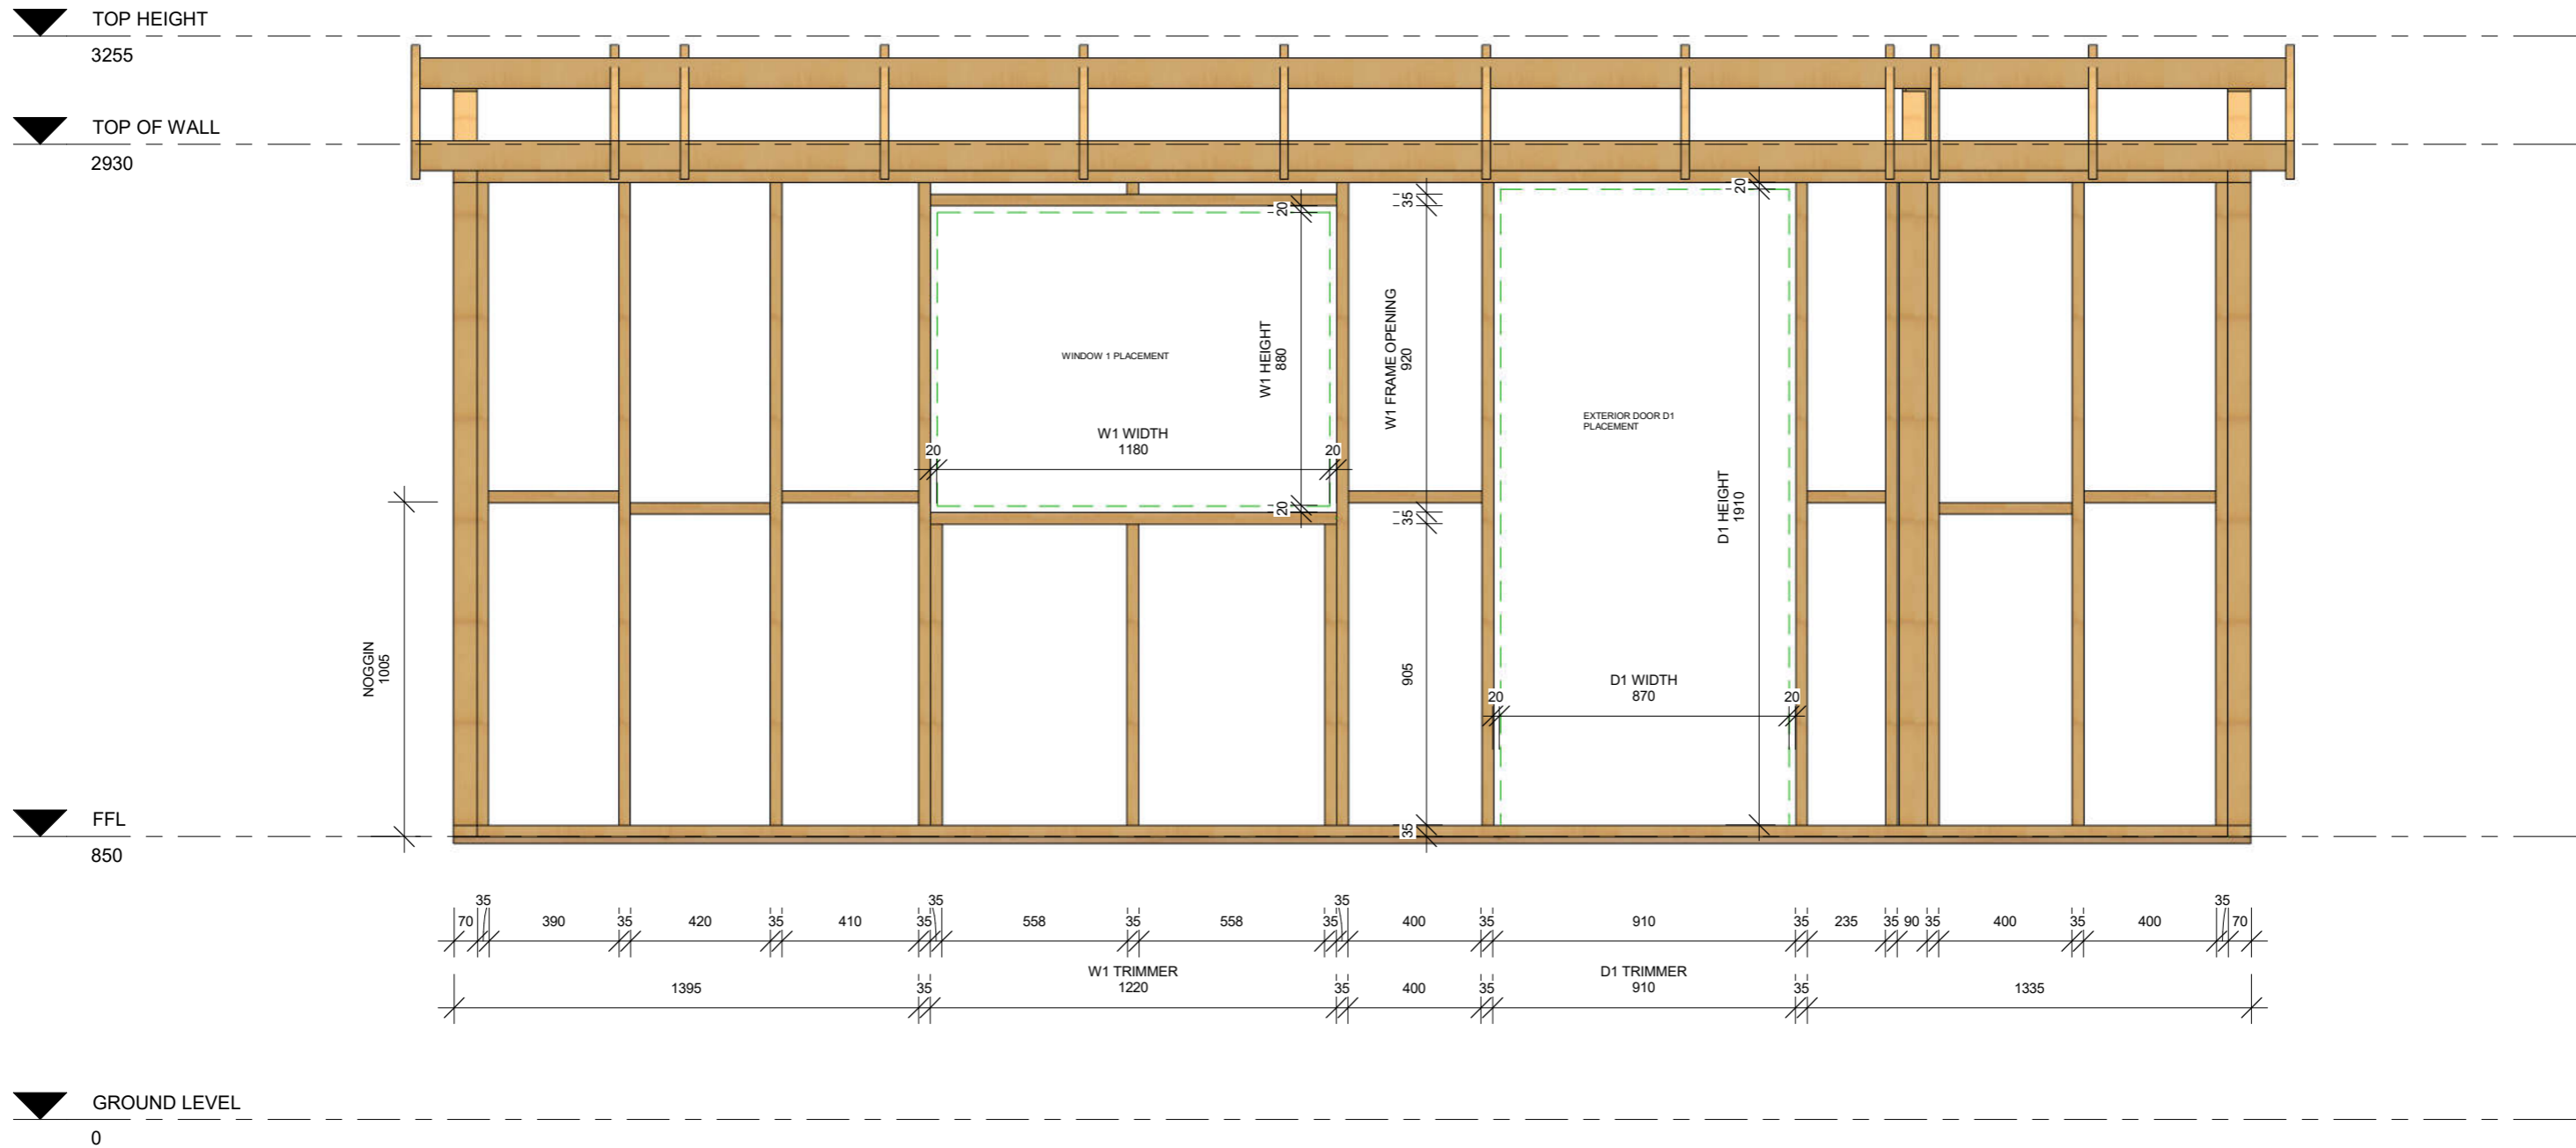


**1** NORTH WALL FRAME  
1 : 20

SCALE	<b>HANGAN SHEPHERD HUT - 5.4M</b>	DRAWING TITLE	PROJECT N°	DATE	SHEET	<b>HANGAN</b> TINY HOMES
1 : 20		NORTH WALL FRAME	Project Number	28/02/2020 14:05:39	A018	

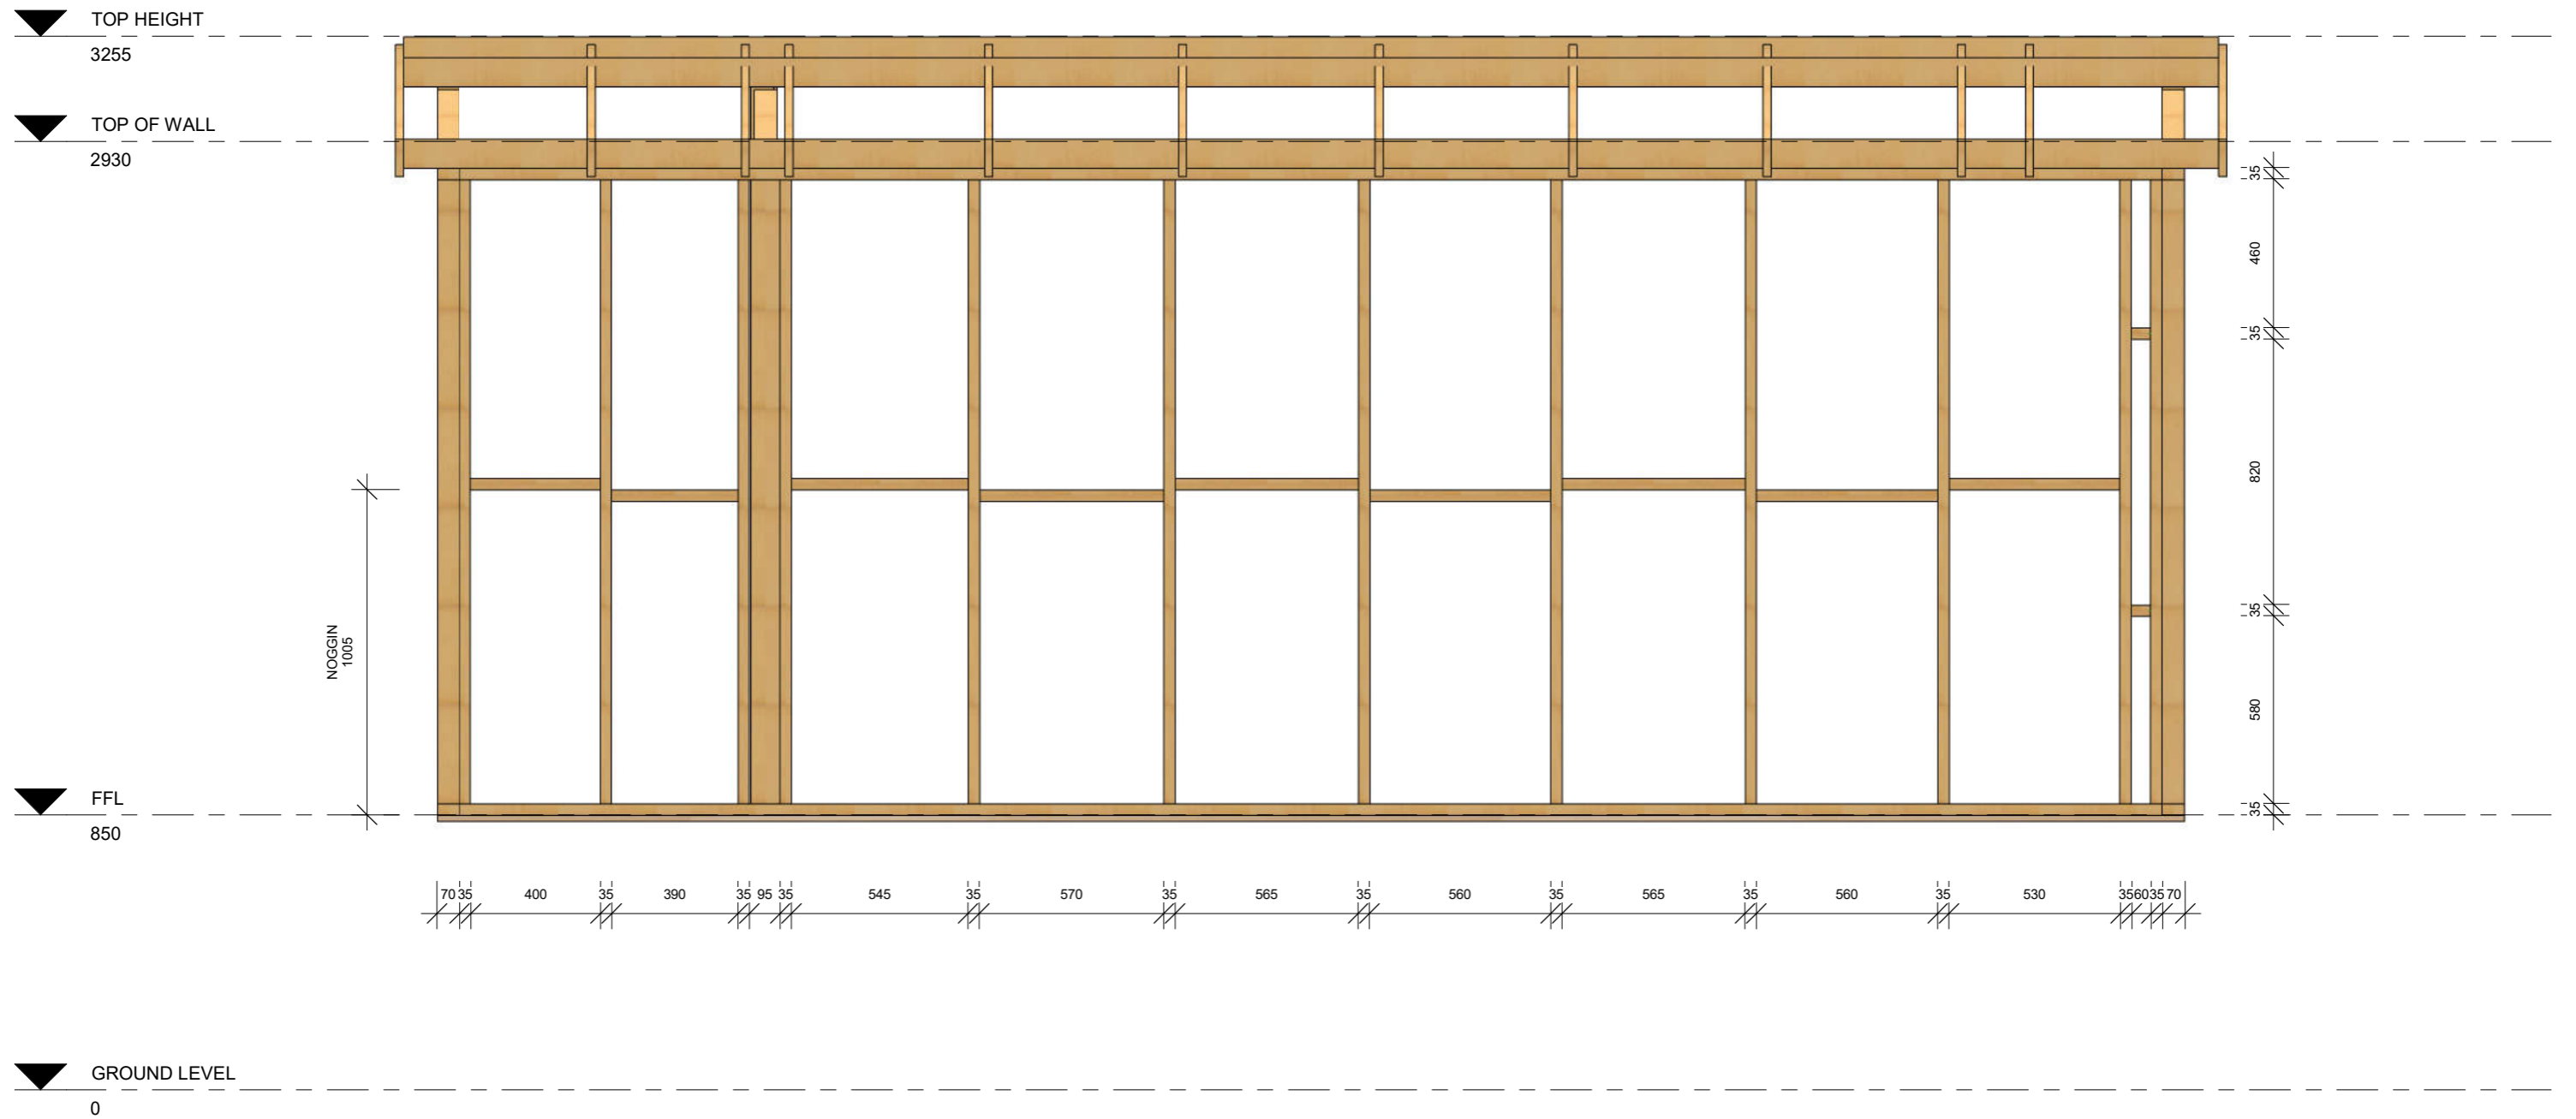


**2 SOUTH WALL FRAME**  
1 : 20

SCALE	<b>HANGAN SHEPHERD HUT - 5.4M</b>	DRAWING TITLE	PROJECT N°	DATE	SHEET	
1 : 20		SOUTH WALL FRAME	Project Number	28/02/2020 14:05:39	A019	

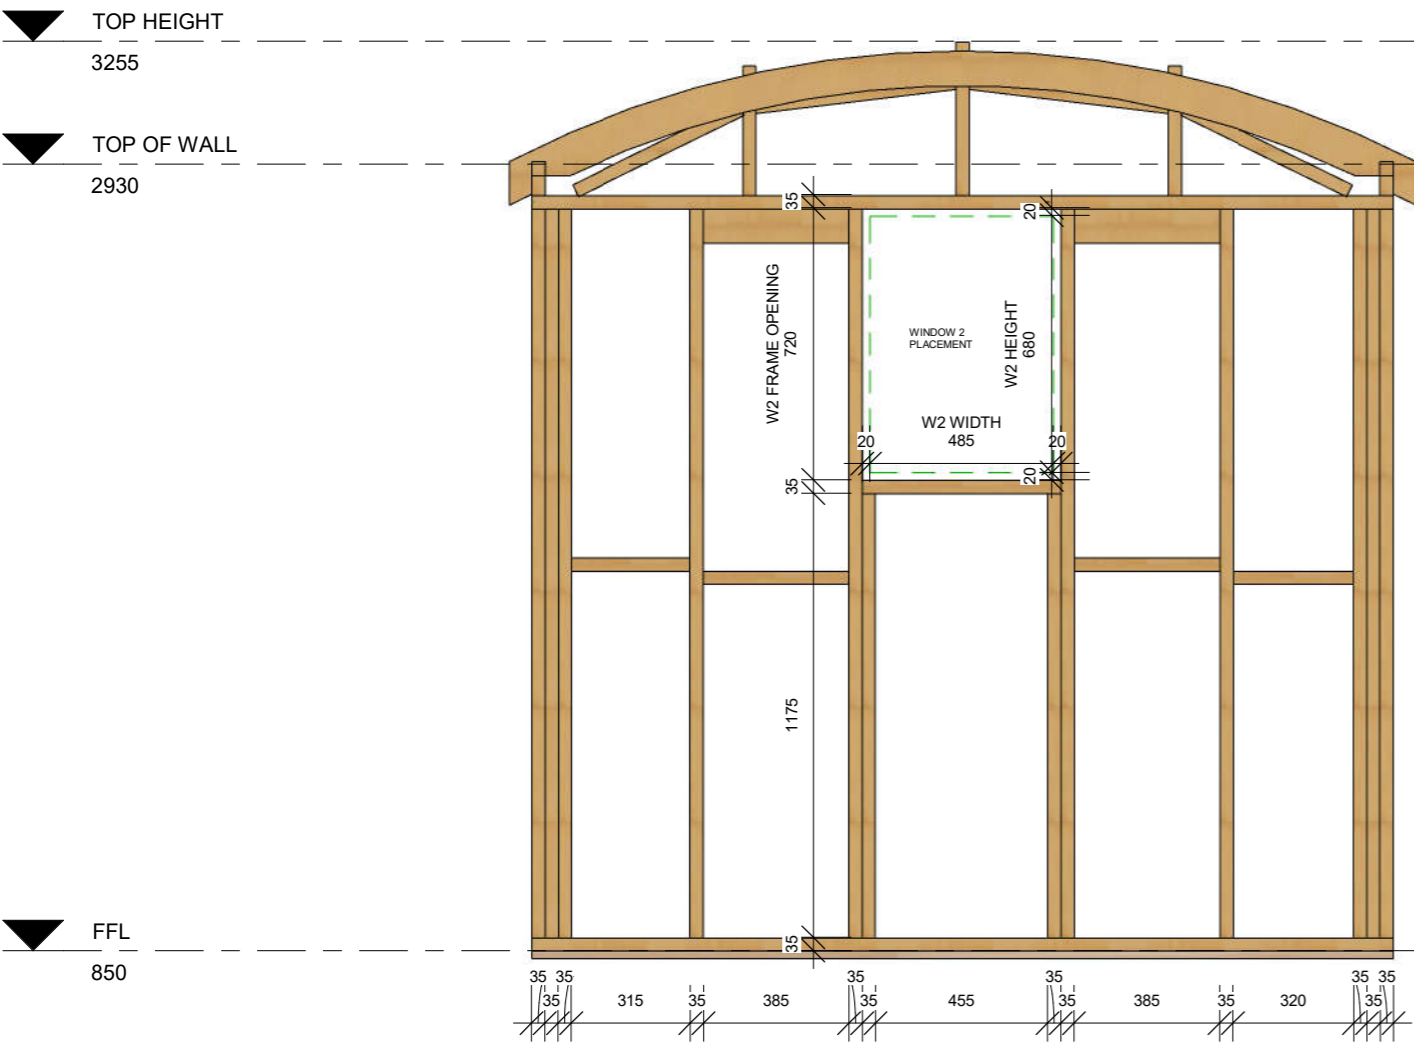


**3 EAST WALL FRAME**  
1 : 20

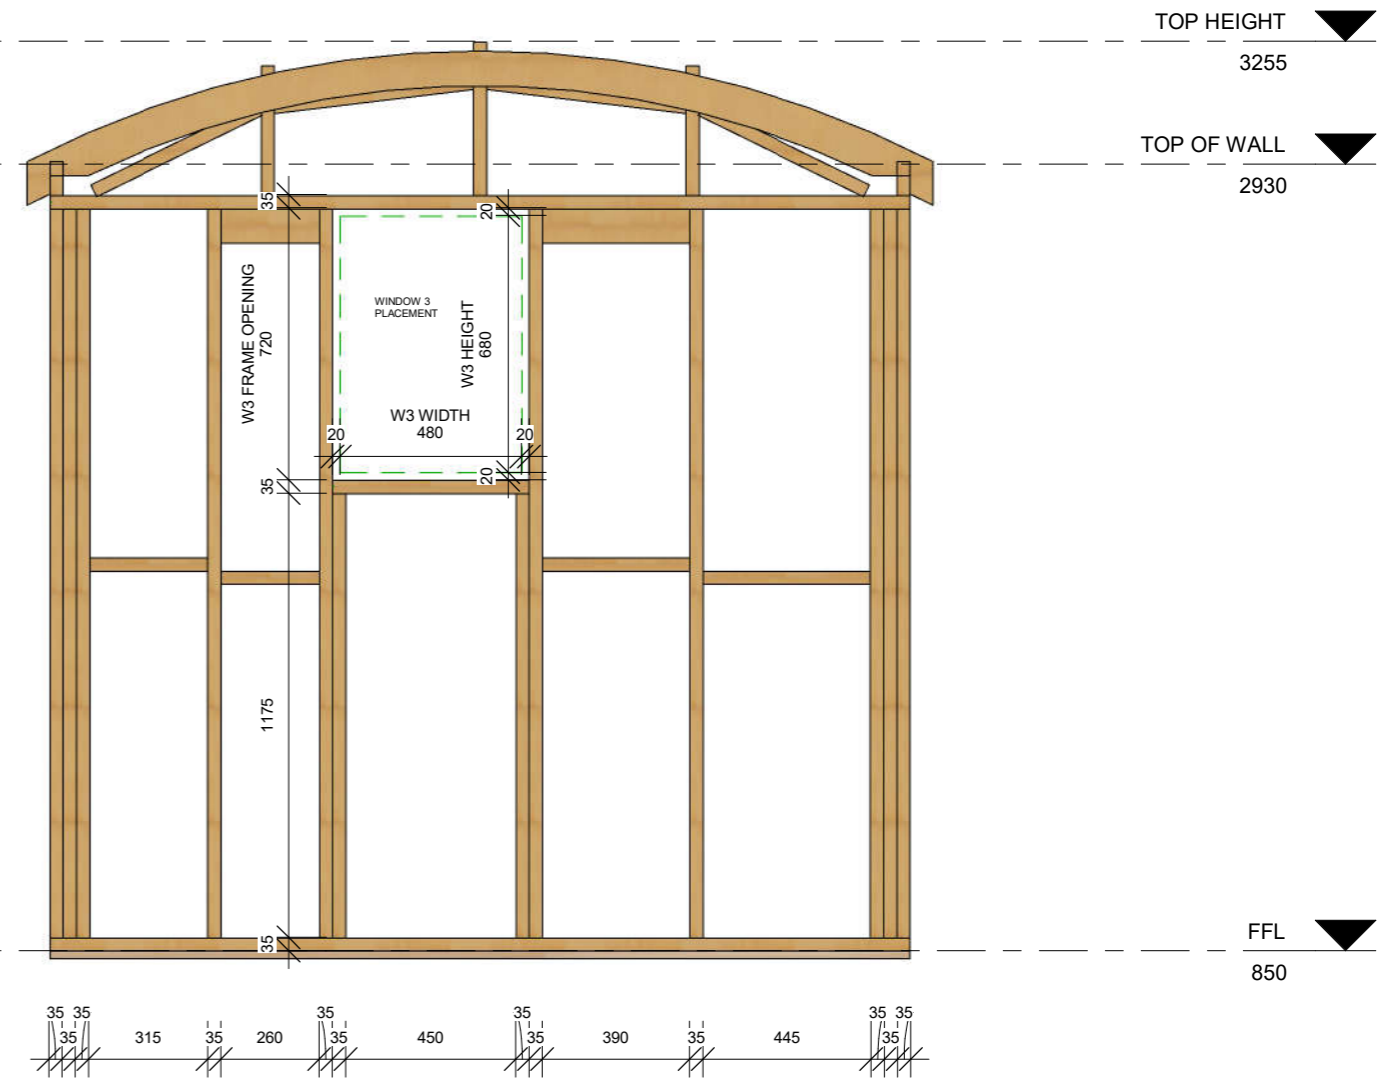

**4 WEST WALL FRAME**  
1 : 20

SCALE	<b>HANGAN SHEPHERD HUT - 5.4M</b>	DRAWING TITLE	PROJECT N°	DATE	SHEET	
		EAST & WEST WALL FRAME	Project Number	28/02/2020 14:05:40	A020	

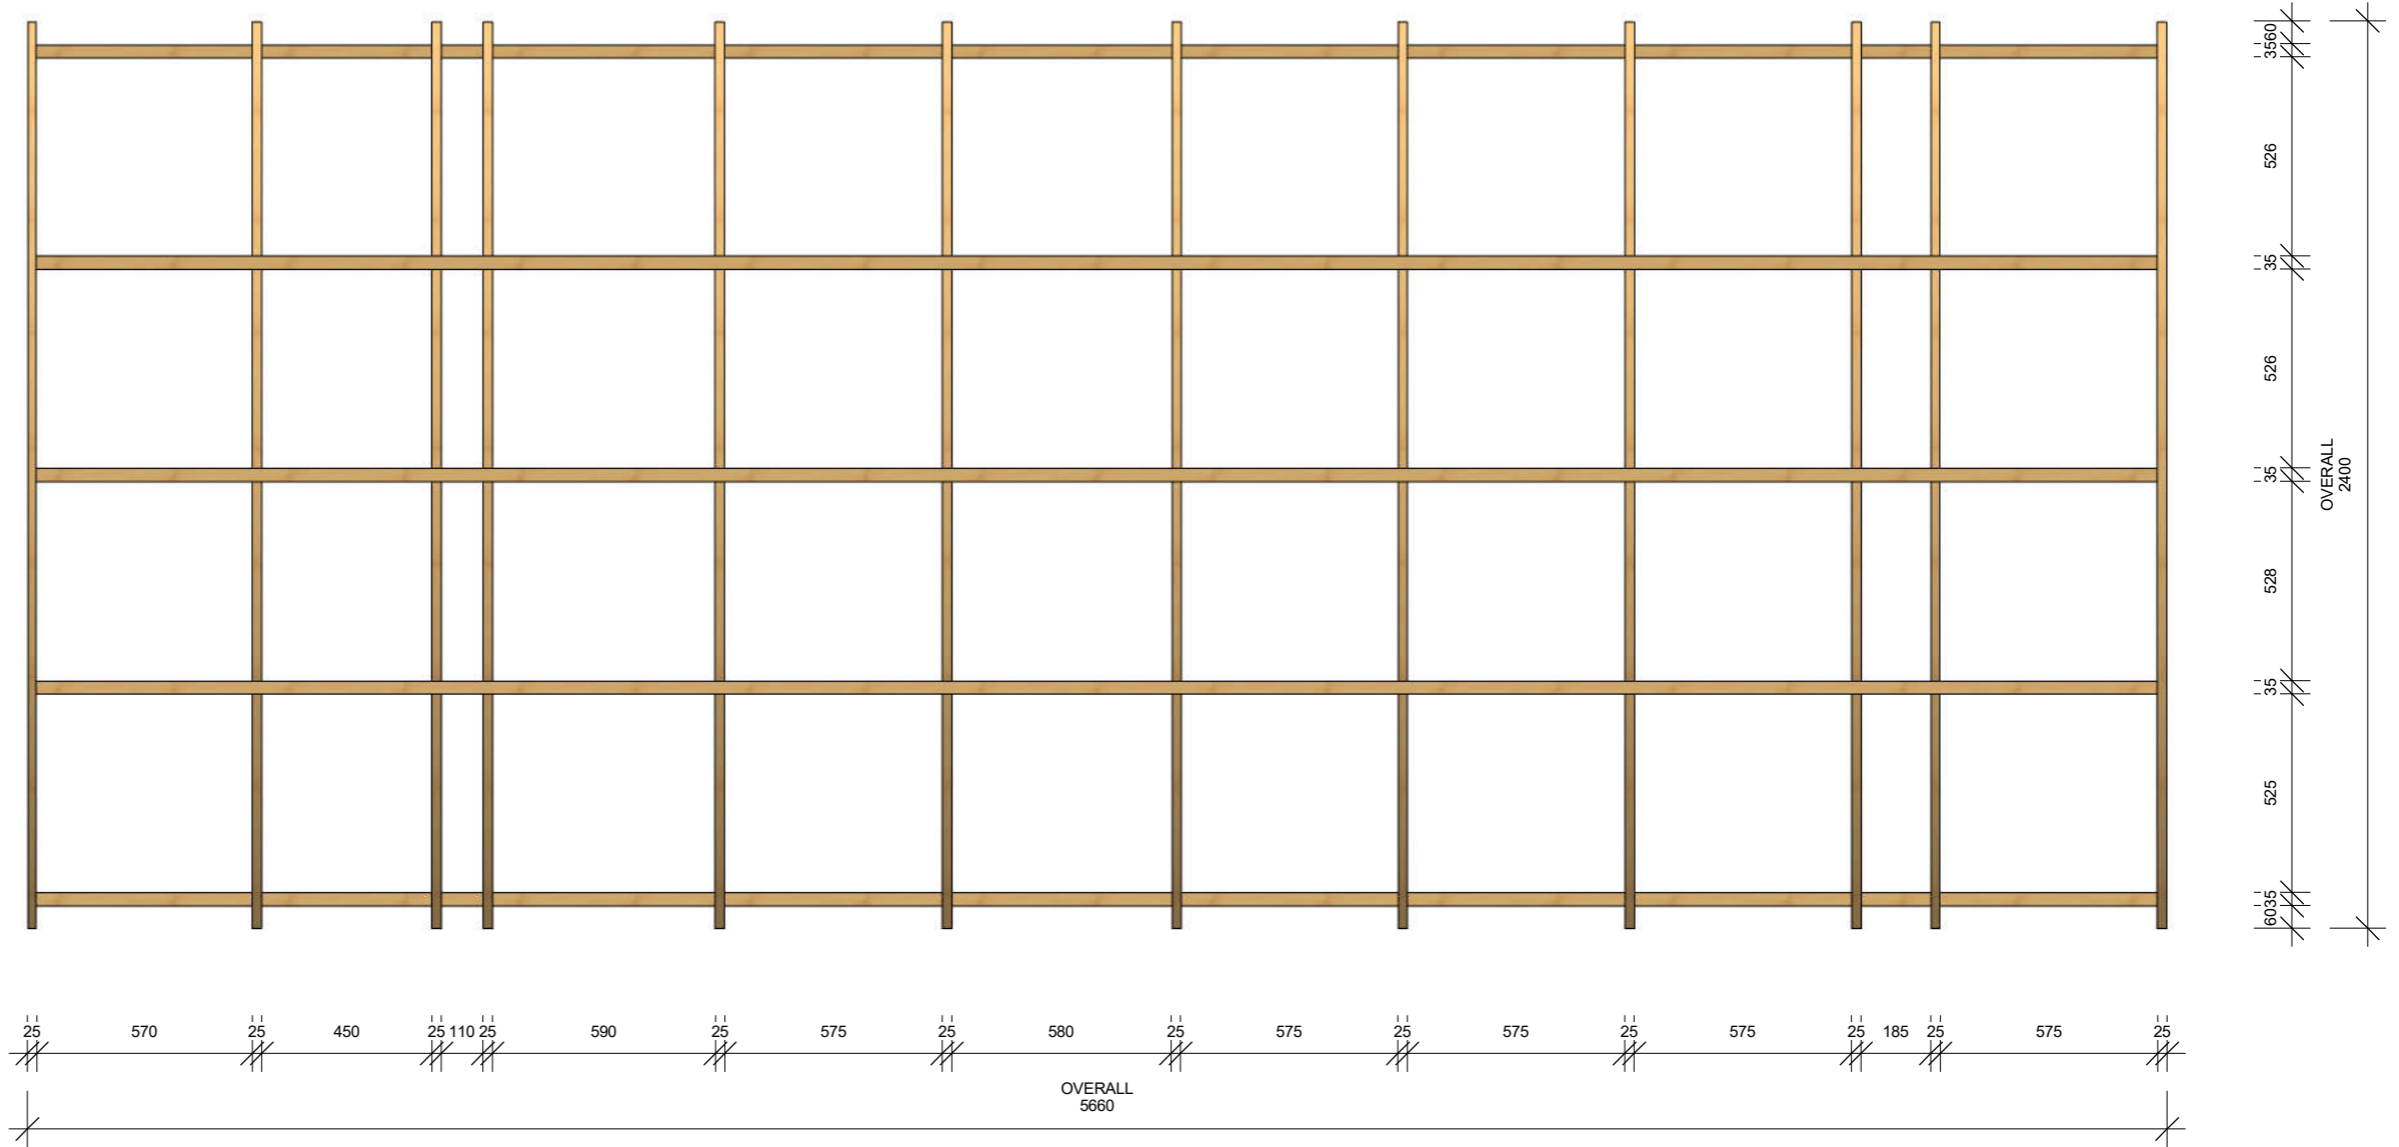

**1** FRAME TOP VIEW  
1 : 20

SCALE	<b>HANGAN SHEPHERD HUT - 5.4M</b>	DRAWING TITLE	PROJECT N°	DATE	SHEET	
1 : 20		FRAME TOP VIEW	Project Number	28/02/2020 14:05:40	A021	